

HAMPSHIRE MEWS
LOT 4
INTERIOR DRAWINGS - LIGHT SCHEME

MAIN FLOOR

ID1	KITCHEN PLAN
ID2	KITCHEN ELEVATIONS 1 & 2
ID3	KITCHEN ISLAND ELEVATIONS
ID4	KITCHEN PANTRY
ID5	POWDER ROOM
ID6	LIVING ROOM FIREPLACE
ID7	MUDROOM

SECOND FLOOR

ID8	PRIMARY BEDROOM HEADBOARD WALL
ID9	PRIMARY ENSUITE
ID10	PRIMARY BEDROOM CLOSET
ID11	GUEST BATHROOM
ID12	LAUNDRY ROOM

BASEMENT

ID13	REC ROOM WET BAR
ID14	GUEST BATHROOM

LIGHTING PLANS


ID15	BASEMENT LIGHTING PLAN
ID16	MAIN FLOOR LIGHTING PLAN
ID17	SECOND FLOOR LIGHTING PLAN

FLOORING FINISHES PLANS


ID18	BASEMENT - FLOORING FINISHES PLAN
ID19	MAIN FLOOR - FLOORING FINISHES PLAN
ID20	SECOND FLOOR - FLOORING FINISHES PLAN

STAIR WALL MOULDING DETAIL

ID21 SECOND FLOOR STAIR WALL MOULDING

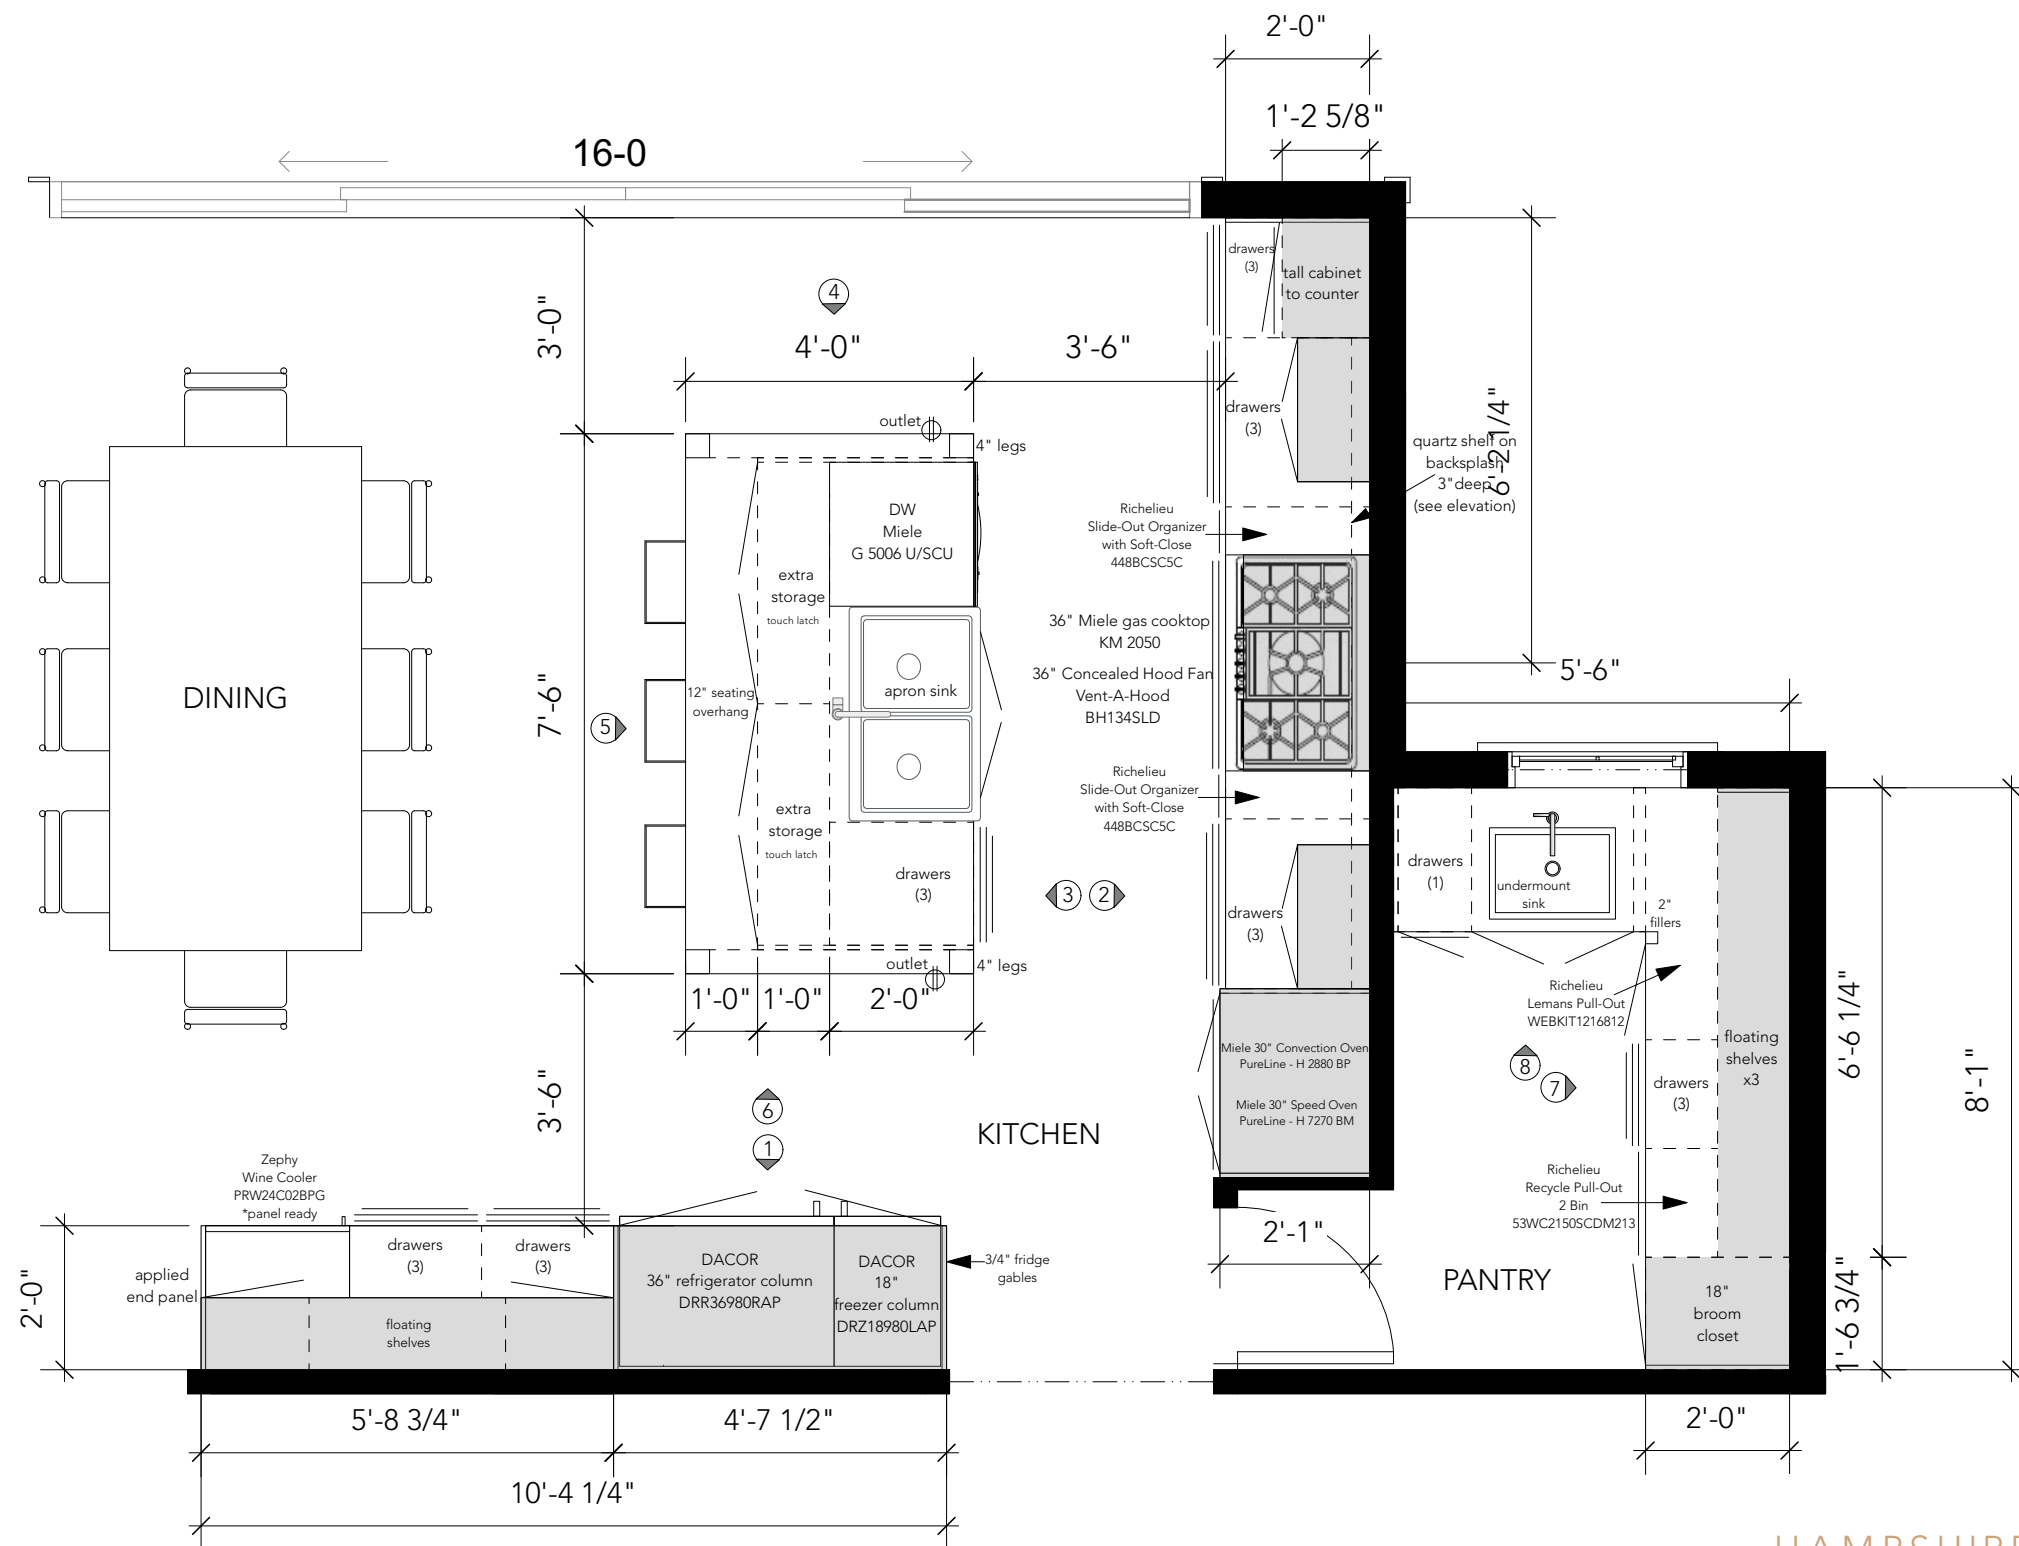

KITCHEN PLAN
SCALE: 3/8" = 1'-0"

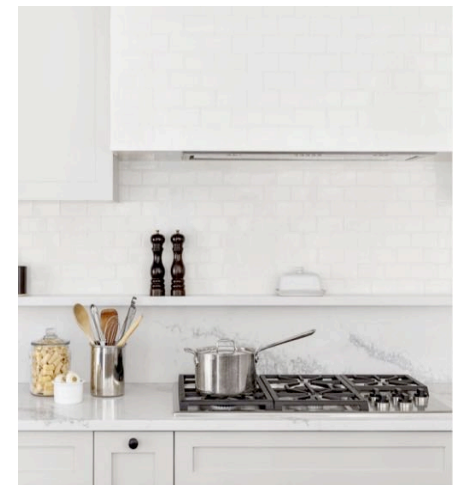

BACKSPLASH DETAIL



TALL CABINET INSPIRATION

HAMPSHIRE MEWS
LOT 4 - LIGHT SCHEME
KITCHEN PLAN
SCALE: 3/8" = 1'-0"

03.01.23

Page: ID1 of 21






INSPIRATION






TALL CABINET CONCEPT

KITCHEN ELEVATIONS
SCALE: 3/8" = 1'-0"

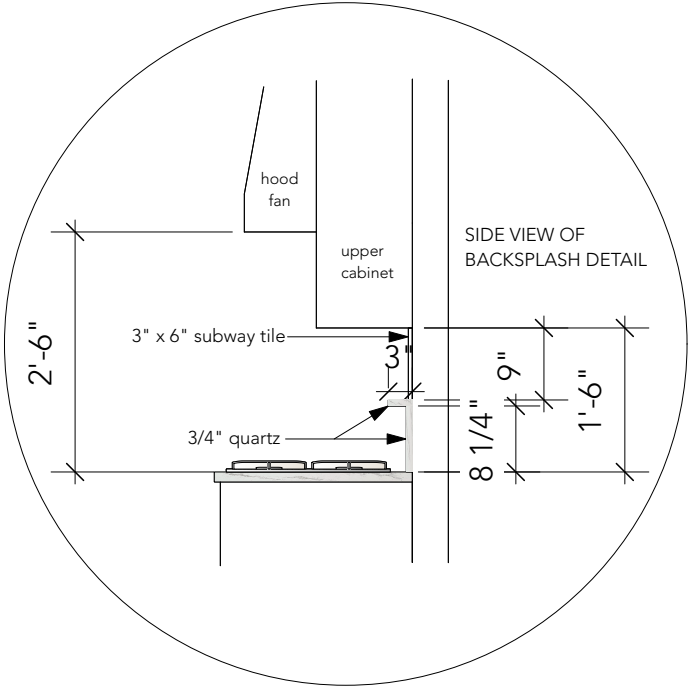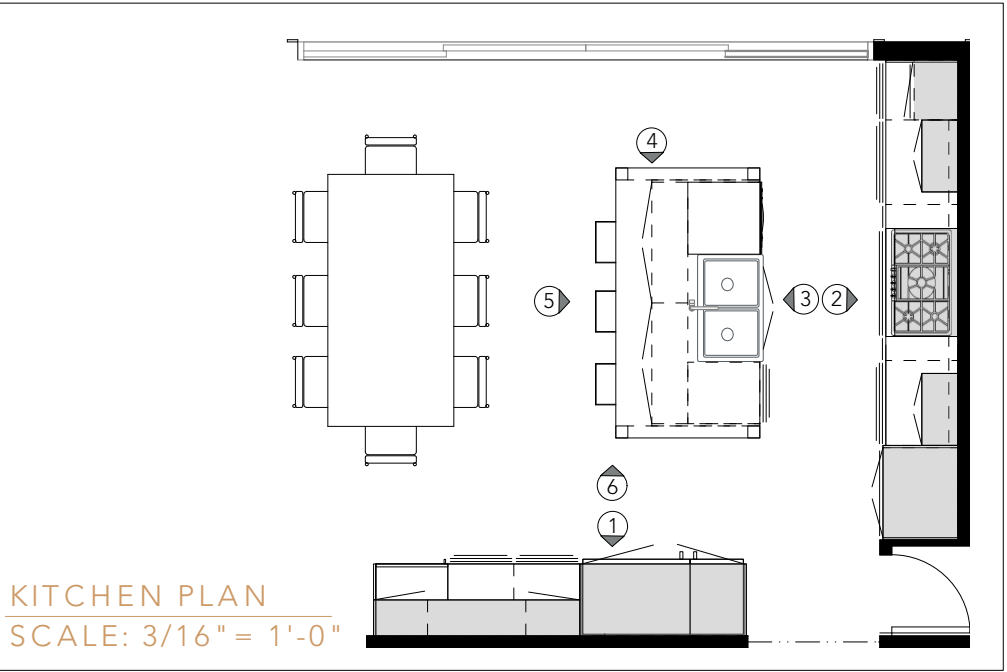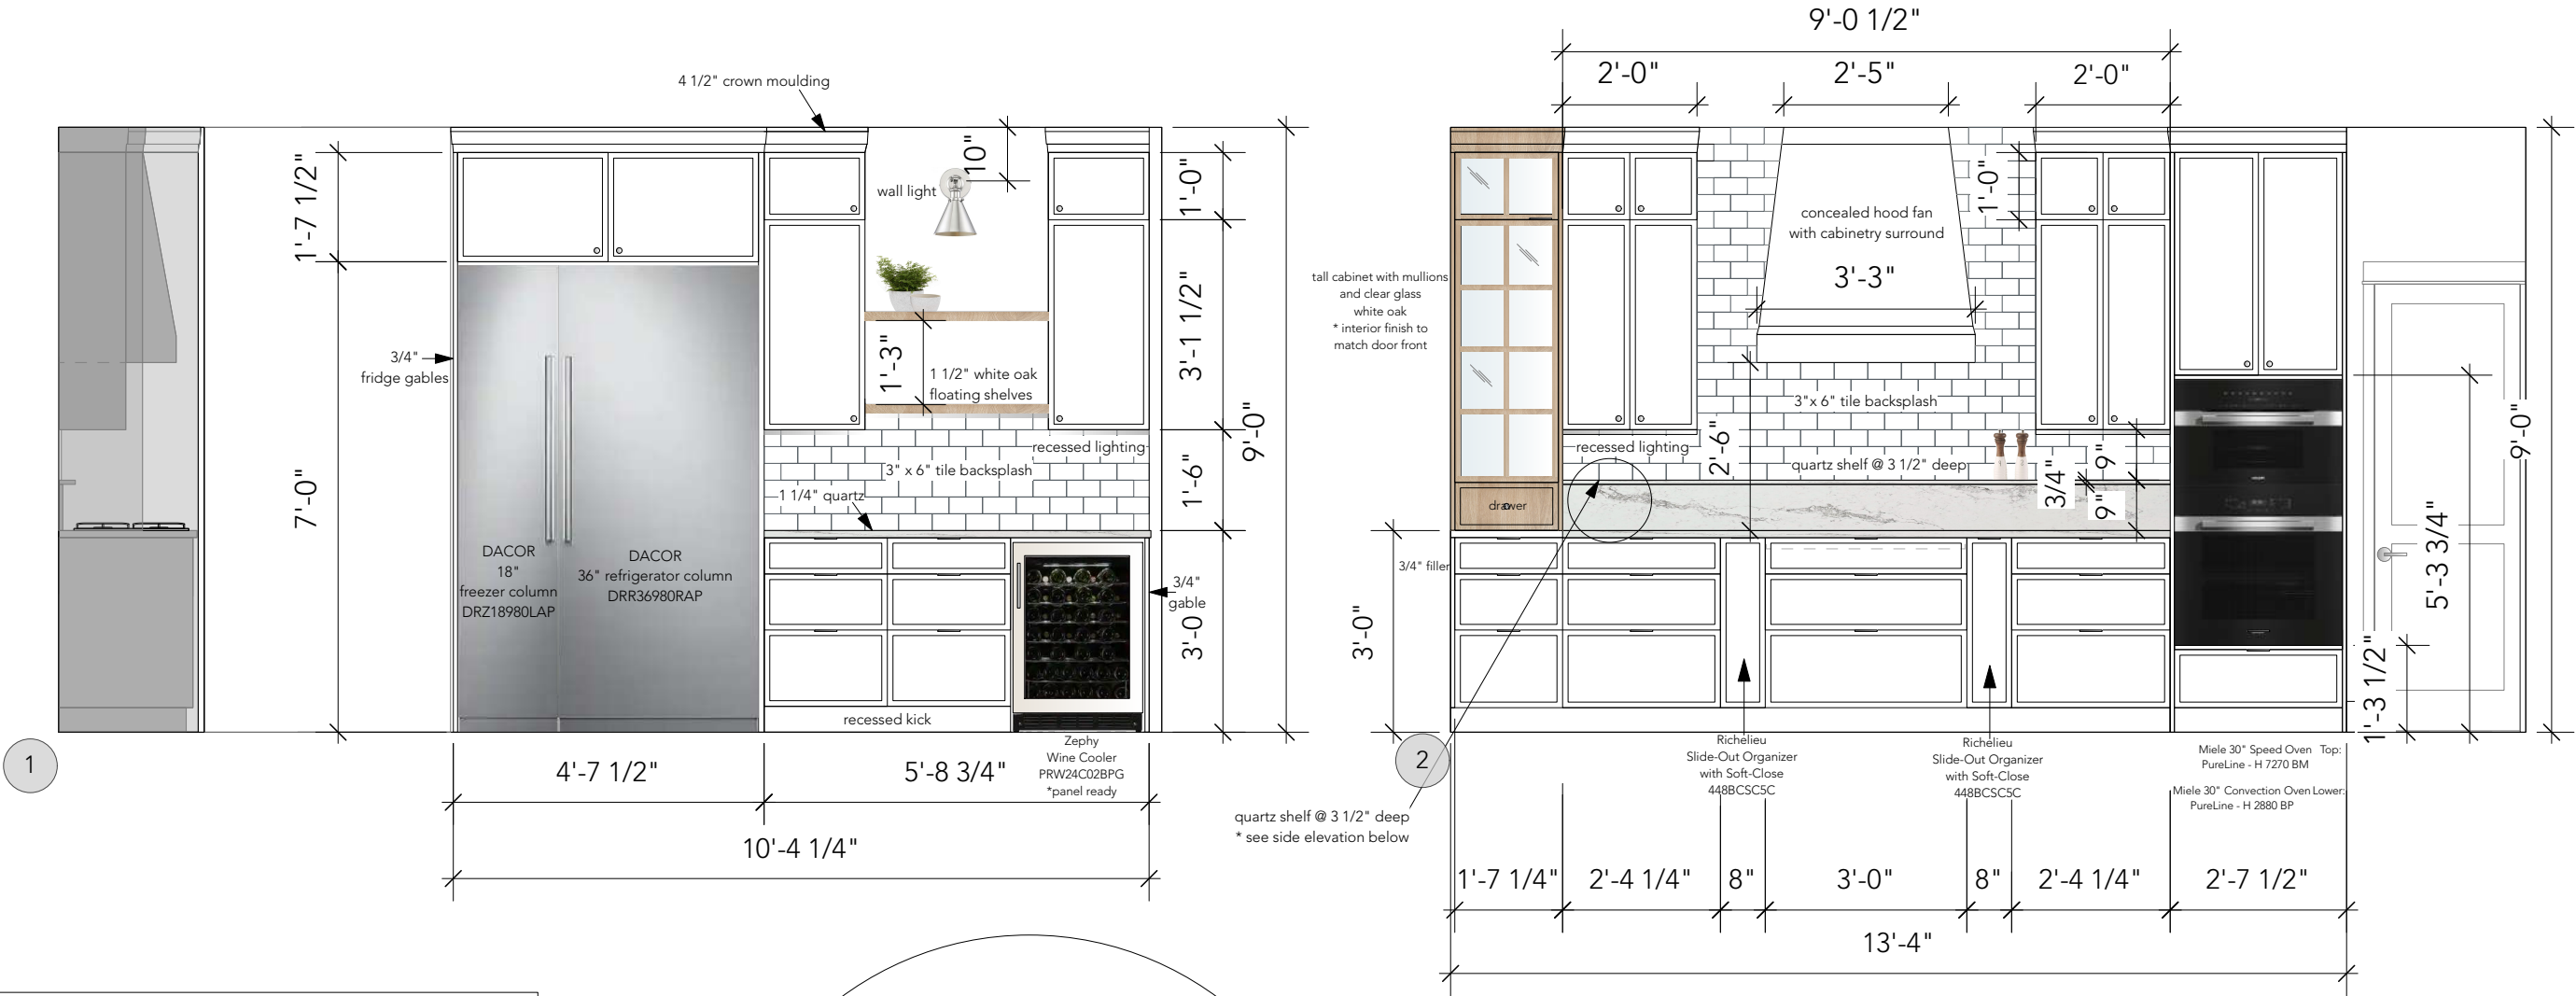


BACKSPASH DETAIL


HAMPSHIRE MEWS
LOT 4 - LIGHT SCHEME
KITCHEN
RANGE WALL & FRIDGE WALL
03.01.23

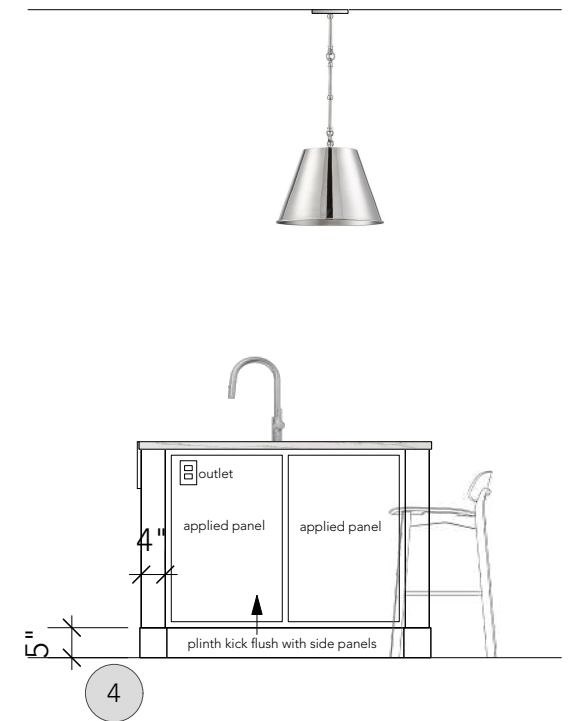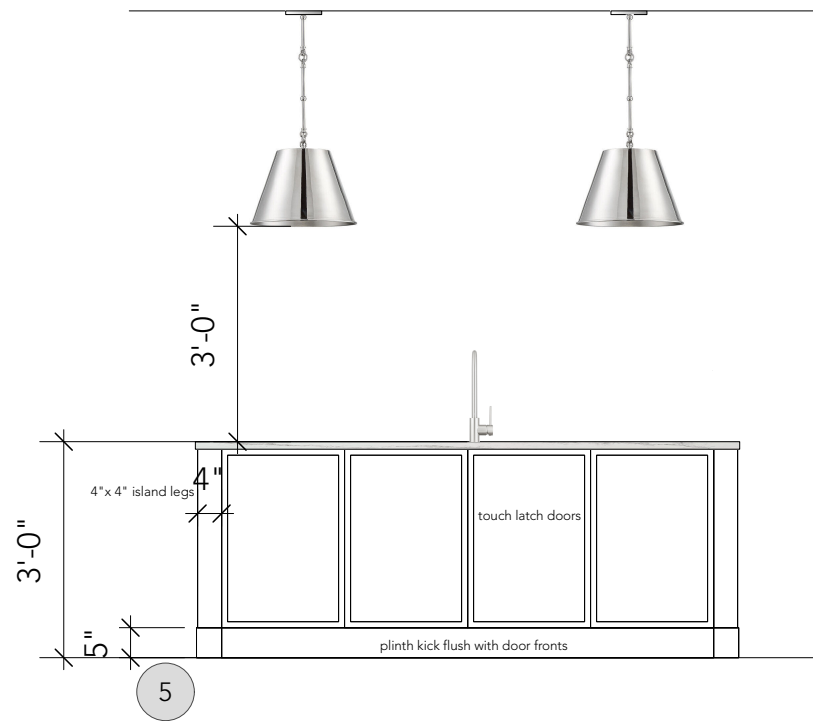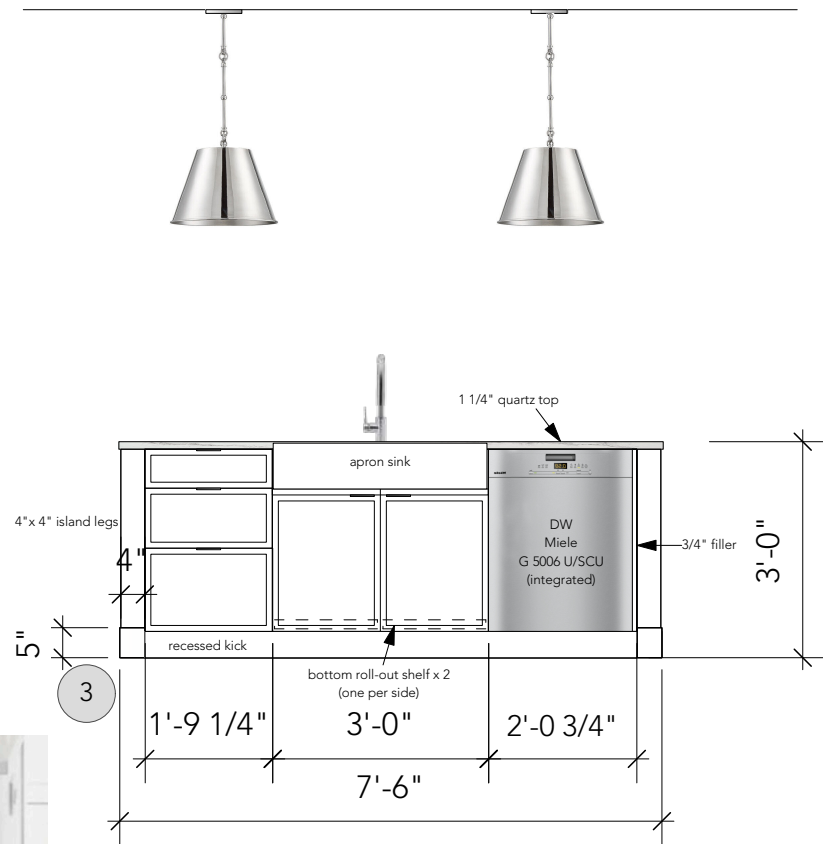

ISLAND LEG DETAIL

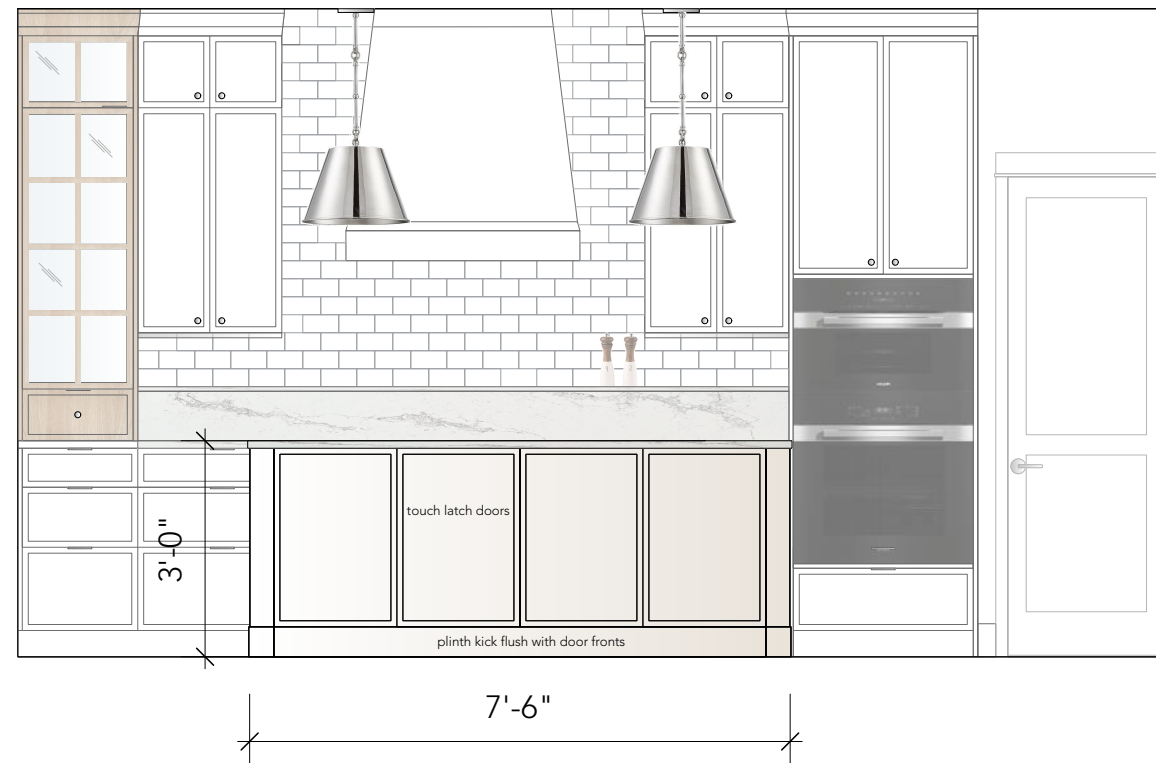




ISLAND ELEVATIONS
SCALE: 3/8" = 1'-0"

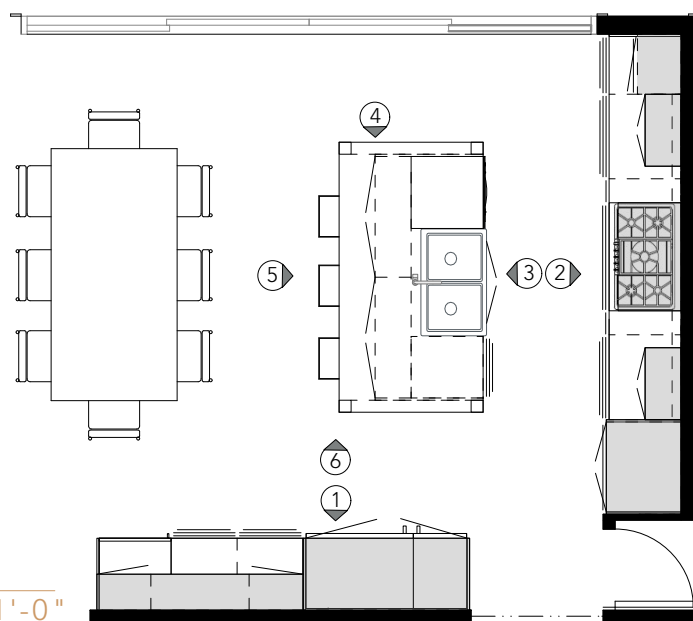

KITCHEN PLAN
SCALE: 3/16" = 1'-0"


HAMPSHIRE MEWS
LOT 4 - LIGHT SCHEME
KITCHEN
ISLAND ELEVATIONS
03.01.23

Page: ID3 of 21

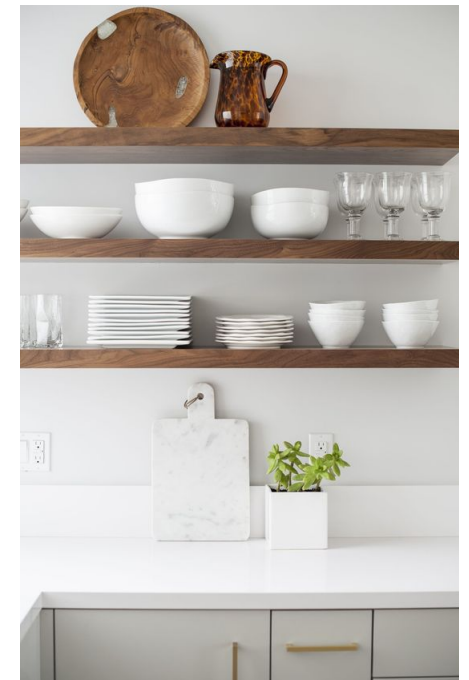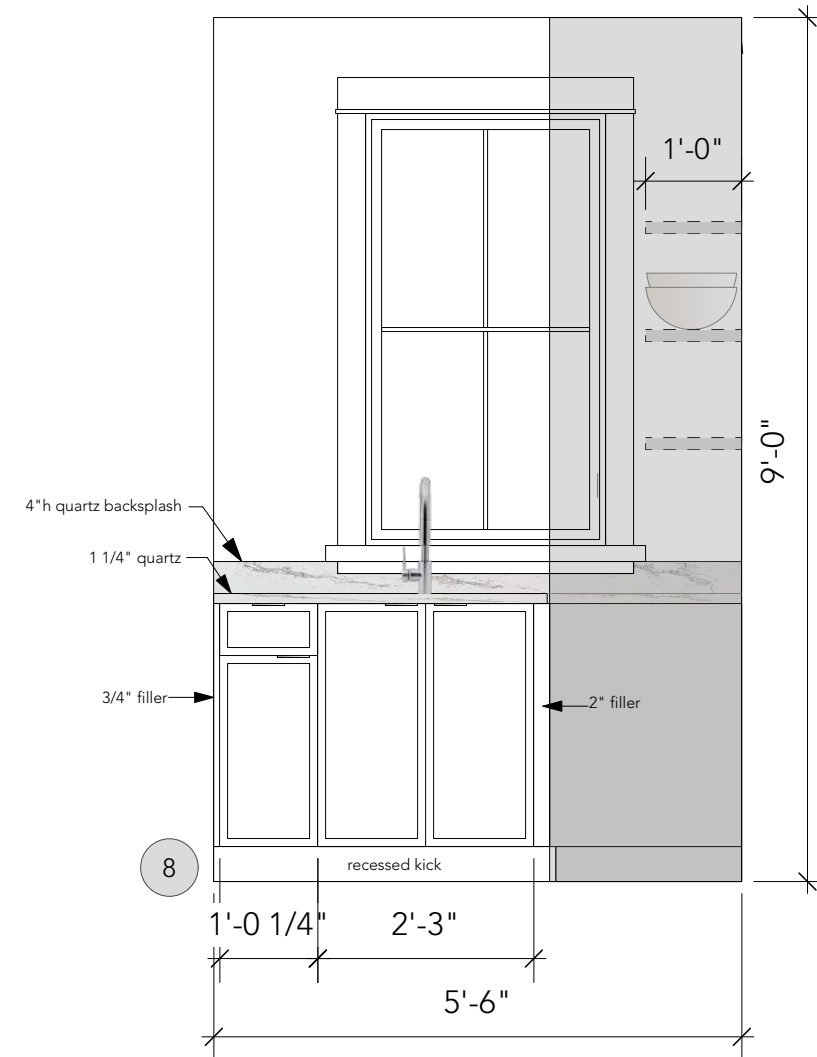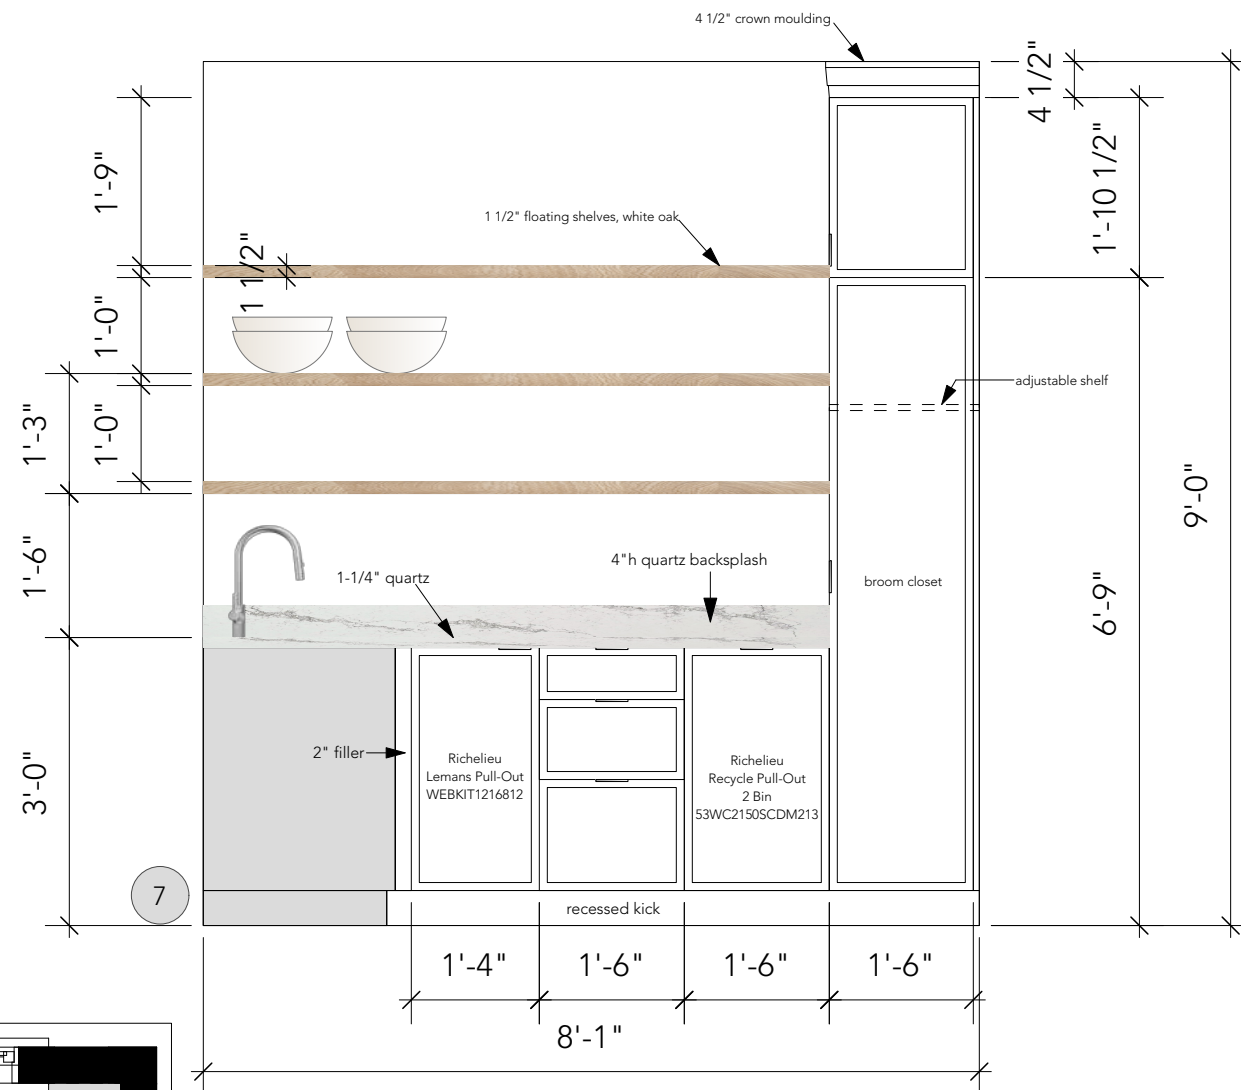

INSPIRATION

PANTRY ELEVATIONS
SCALE: 1/2" = 1'-0"

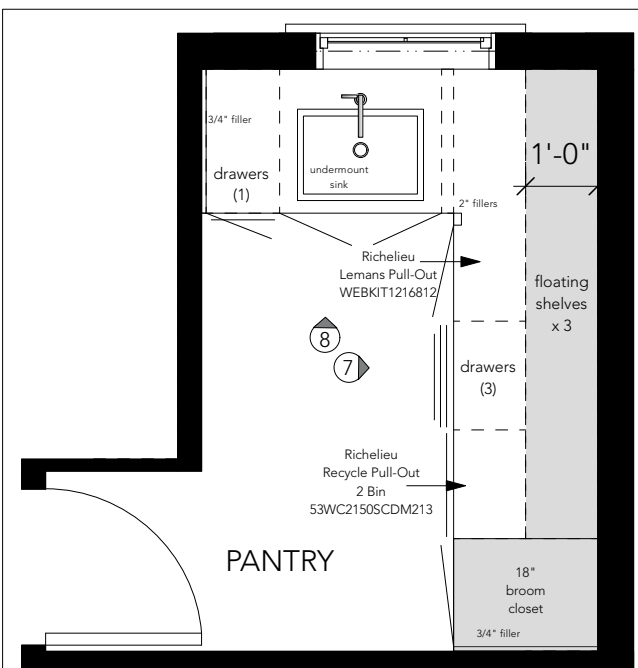




PANTRY PLAN
SCALE: 3/8" = 1'-0"

HAMPSHIRE MEWS
LOT 4 - LIGHT SCHEME
KITCHEN
PANTRY ELEVATIONS
03.01.23

Page: ID4 of 21



INSPIRATION

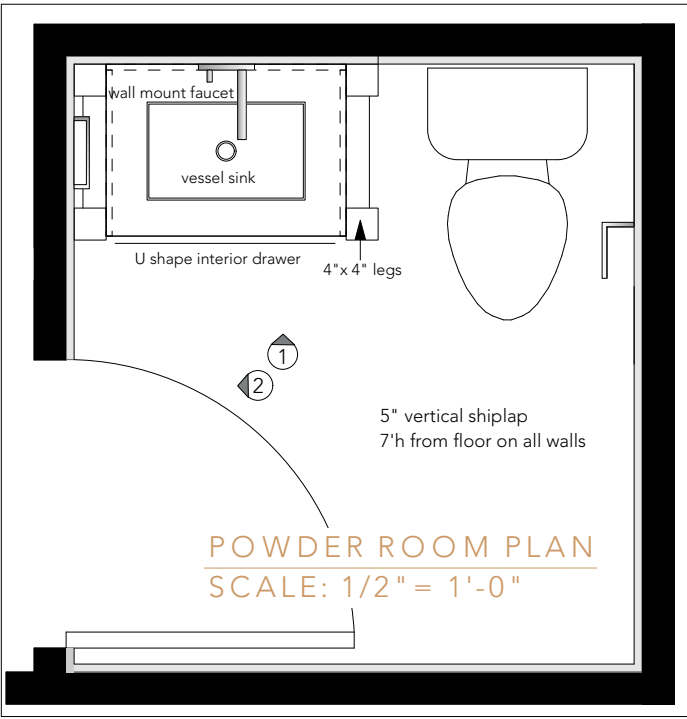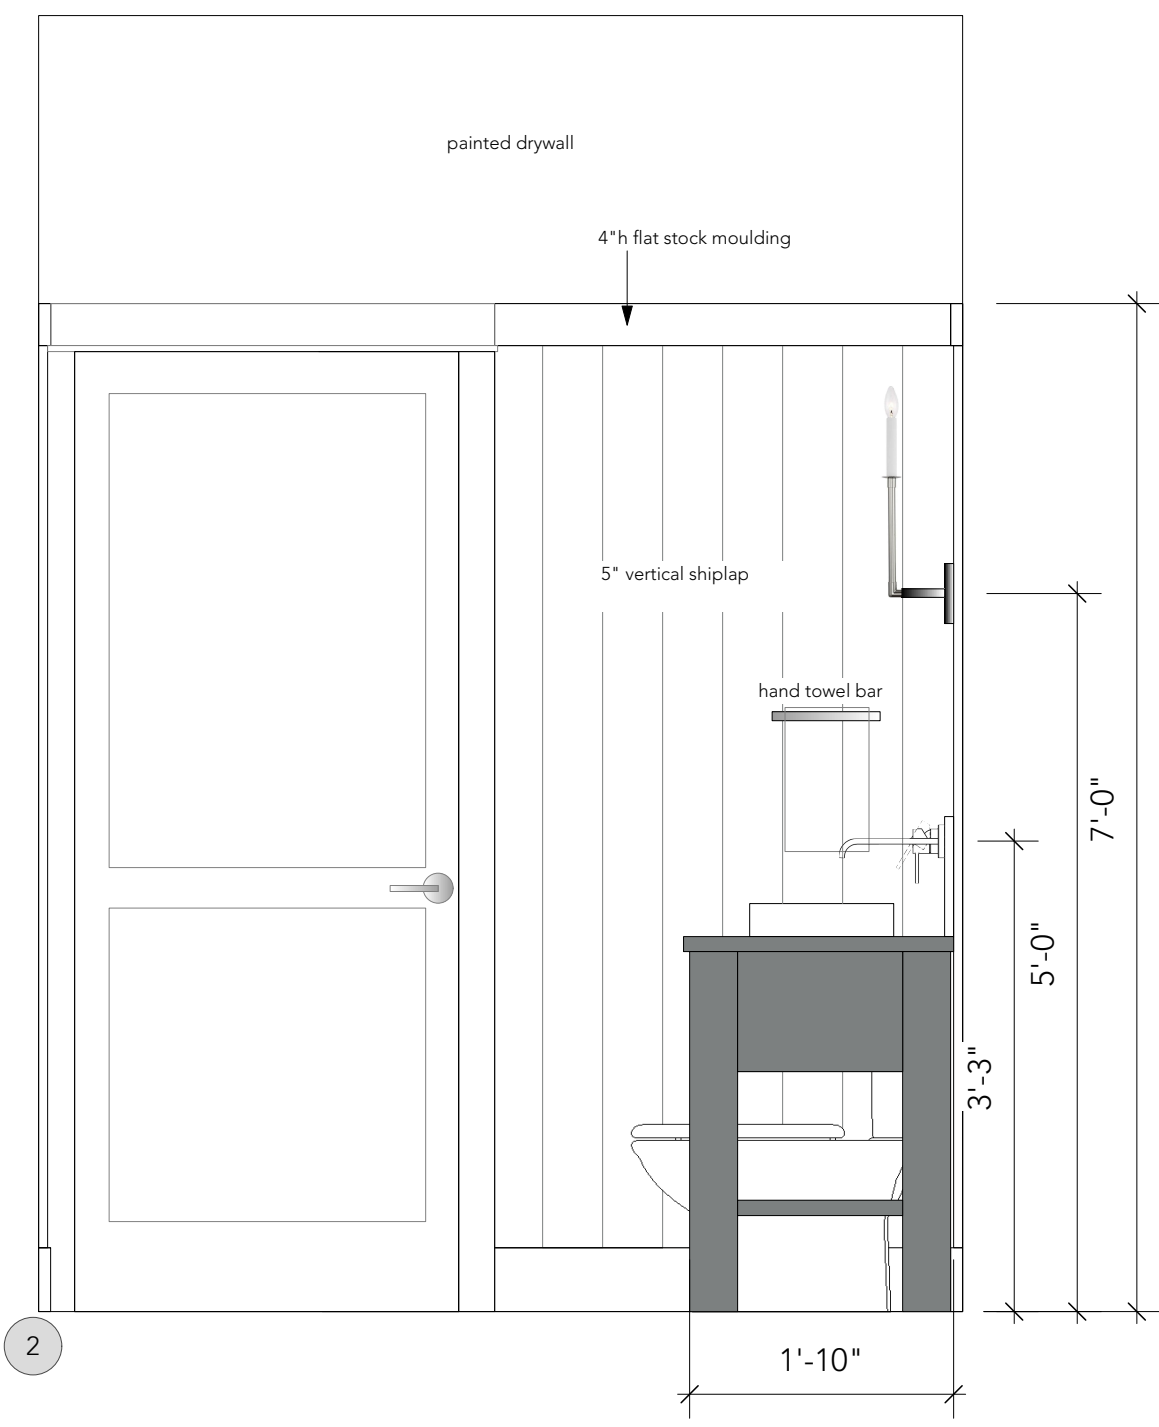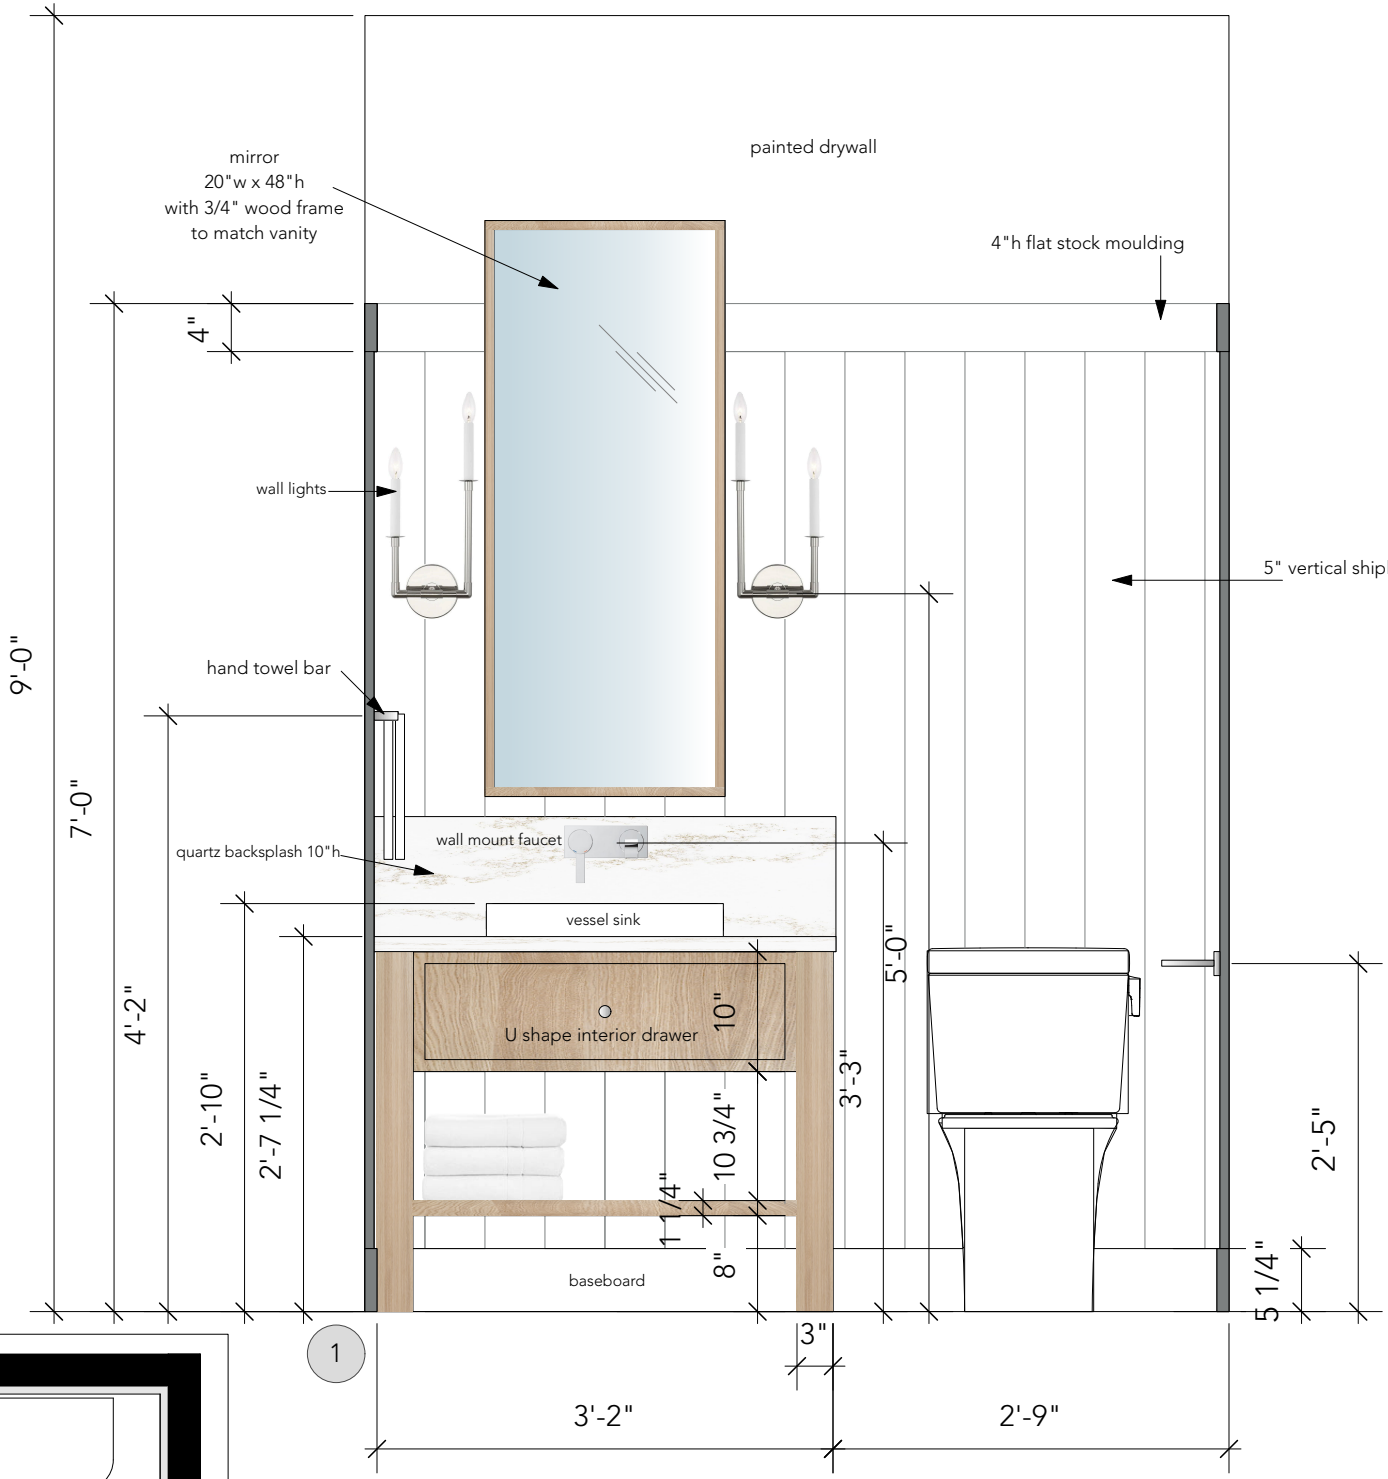

POWDER ROOM ELEVATIONS
SCALE: 3/4" = 1'-0"


HAMPSHIRE MEWS
LOT 4 - LIGHT SCHEME
POWDER ROOM
03.01.23




INSPIRATION




FIREPLACE ELEVATIONS
SCALE: 1/2" = 1'-0"

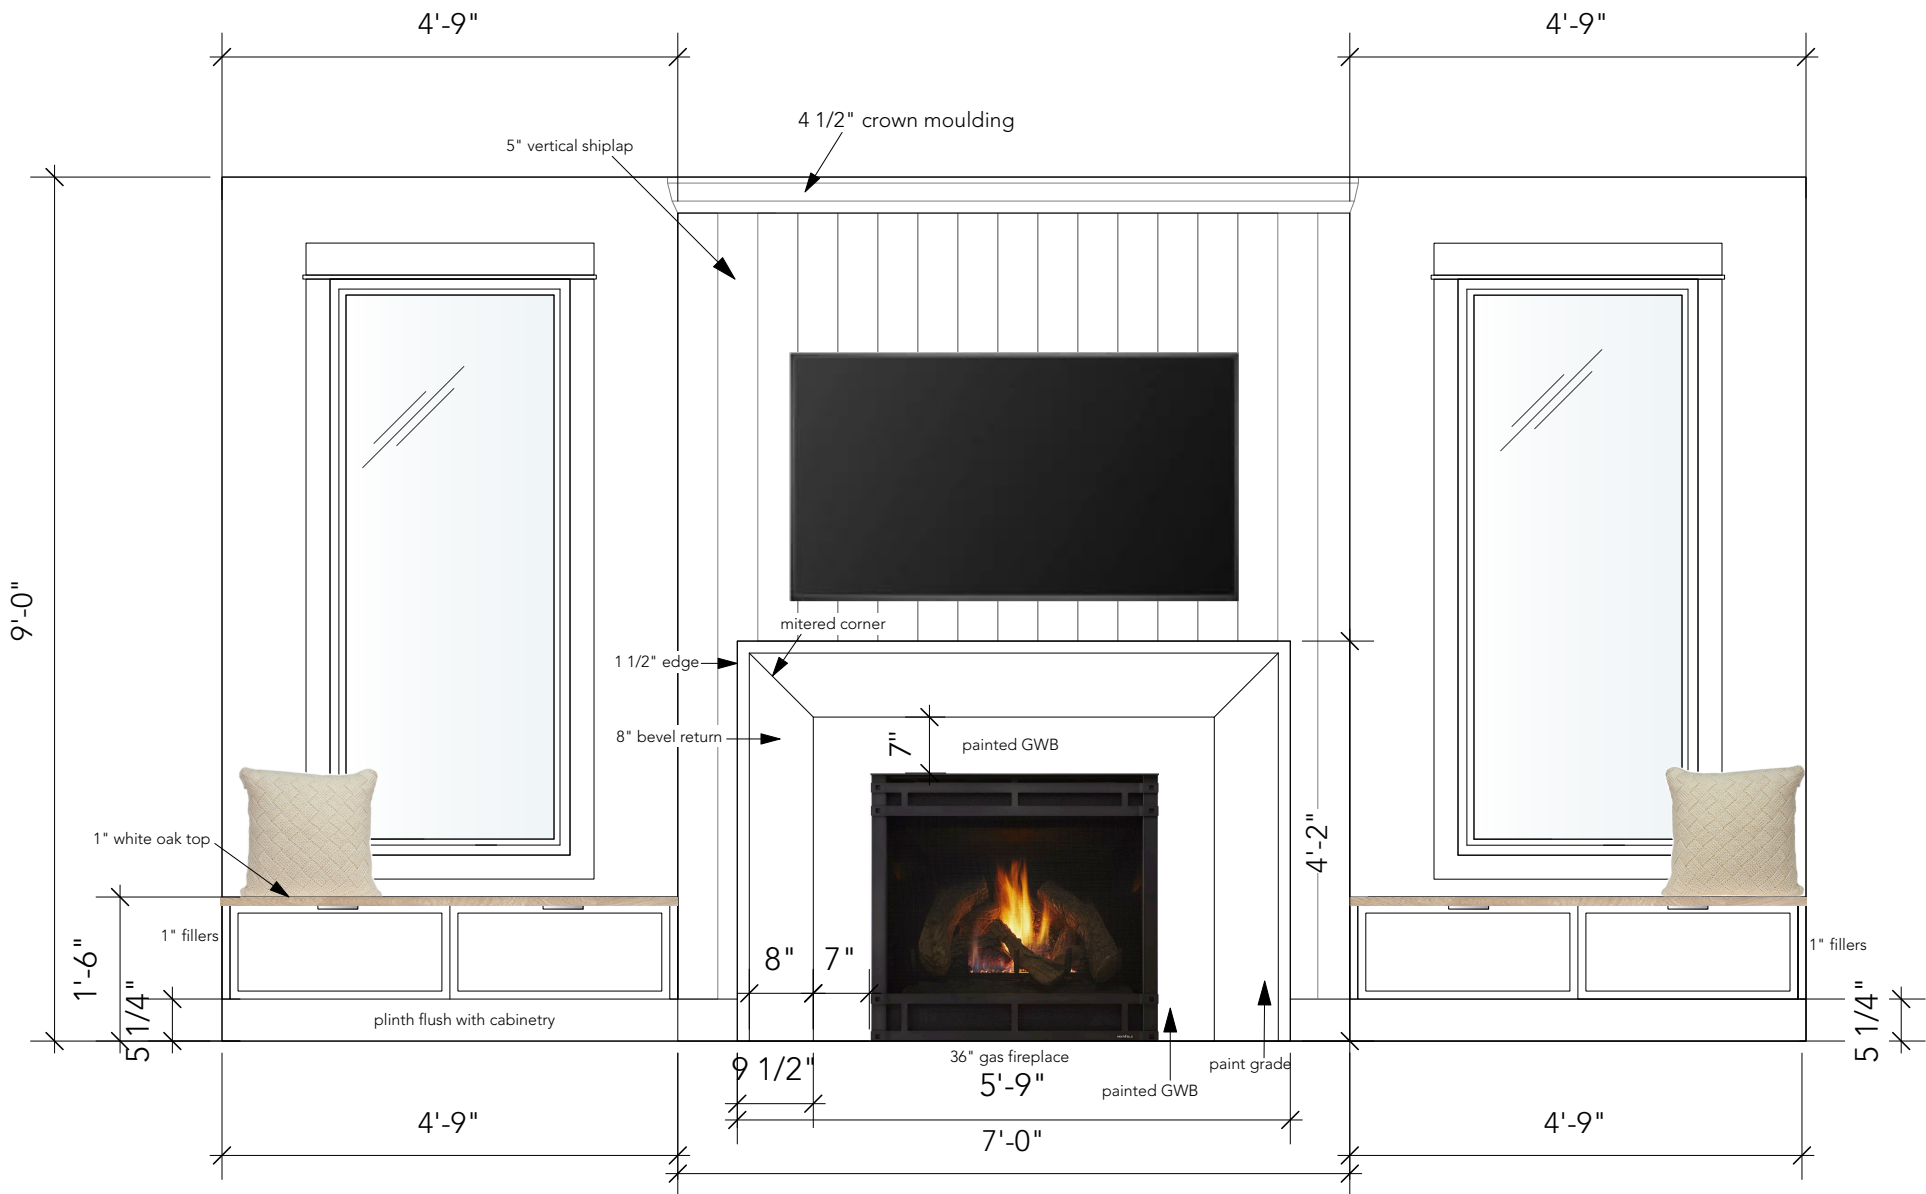

FRONT ELEVATION
SCALE: 1/2" = 1'-0"

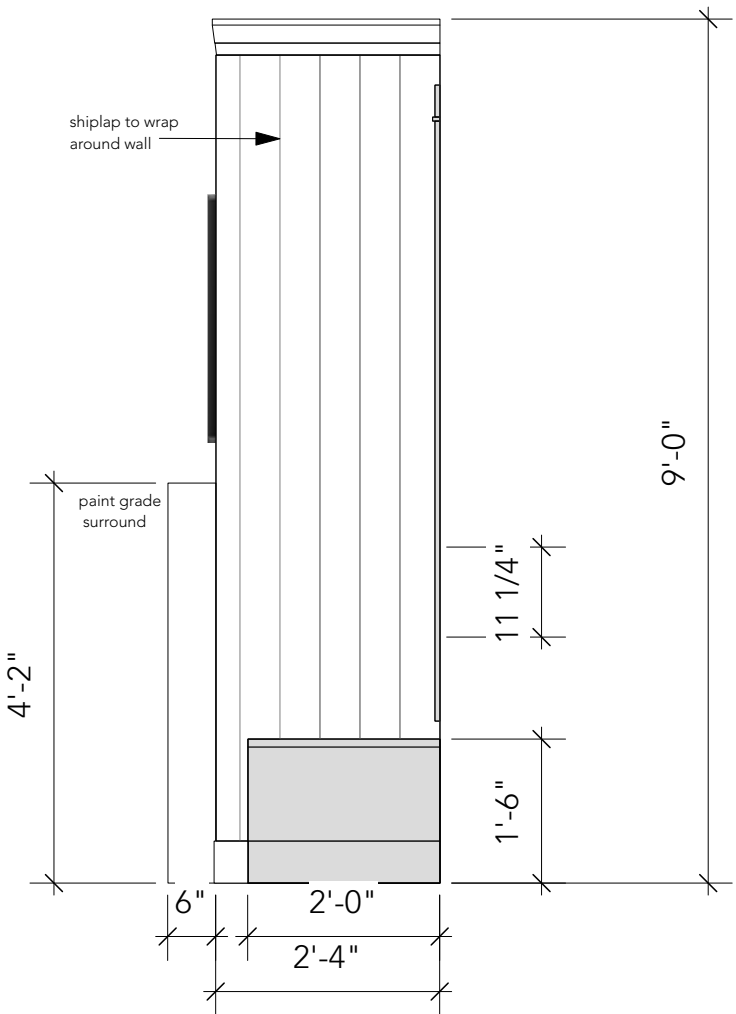

SIDE VIEW
SCALE: 1/2" = 1'-0"


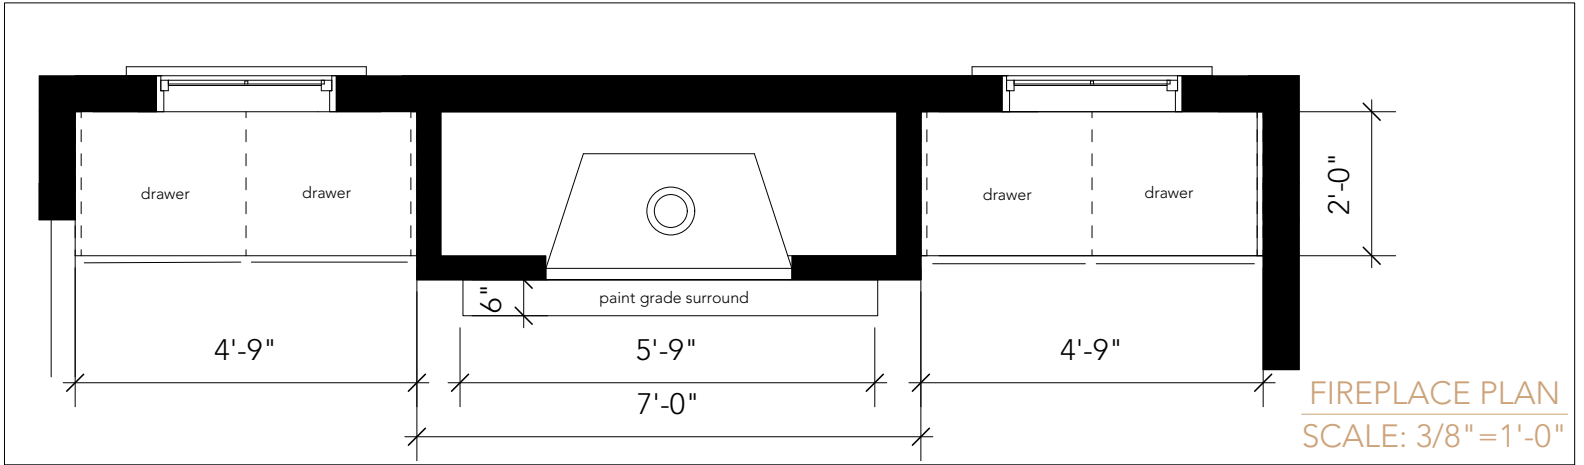


FIREPLACE PLAN
SCALE: 3/8" = 1'-0"


HAMPSHIRE MEWS
LOT 4 - LIGHT SCHEME
LIVING ROOM FIREPLACE
03.01.23



INSPIRATION

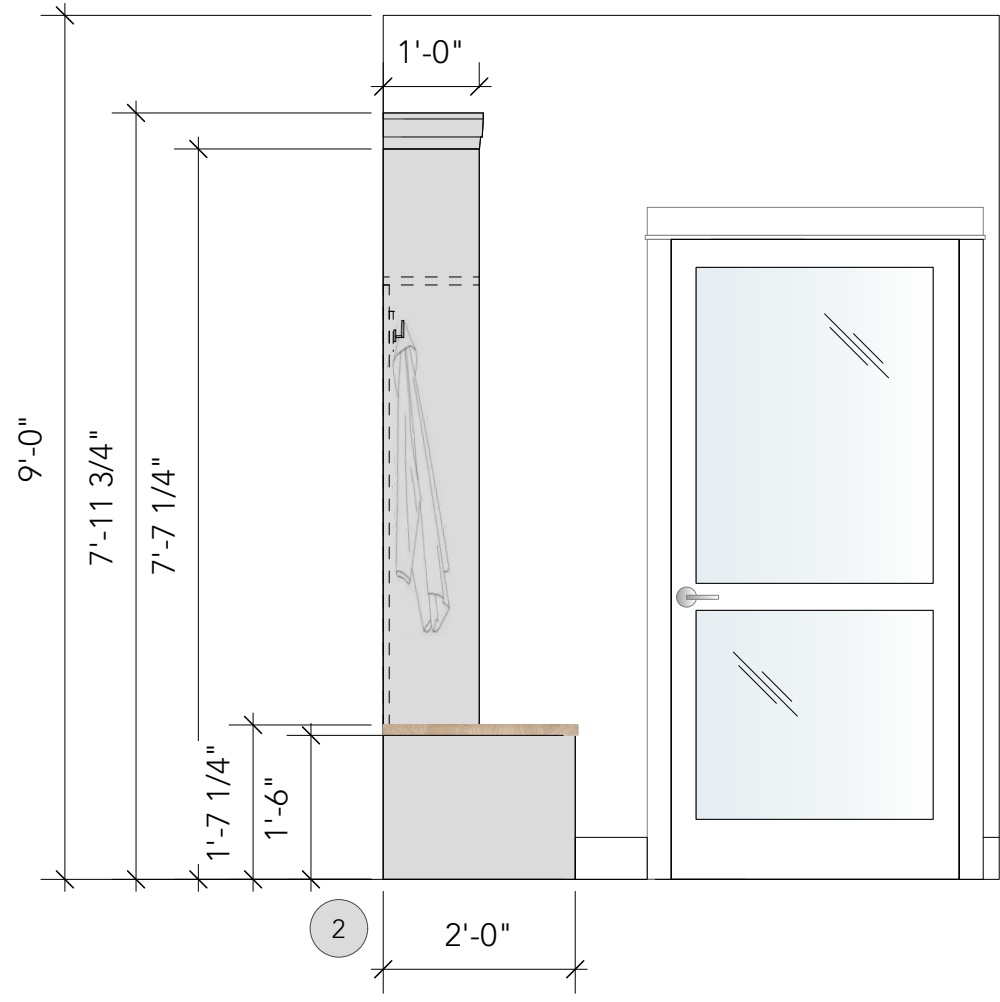
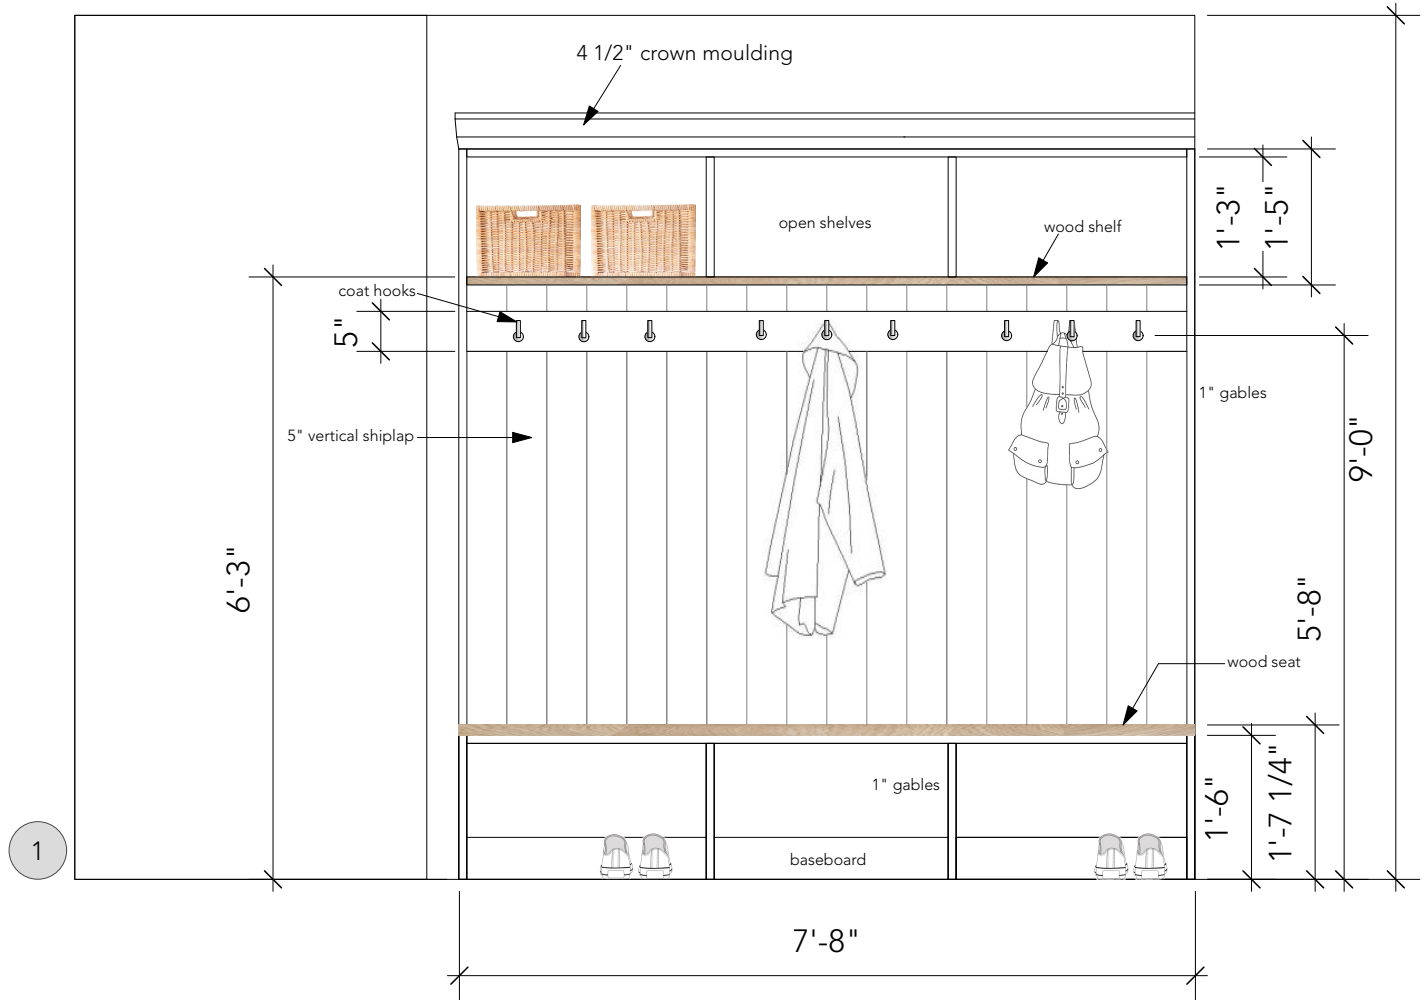


MUDROOM ELEVATIONS
SCALE: 1/2" = 1'-0"

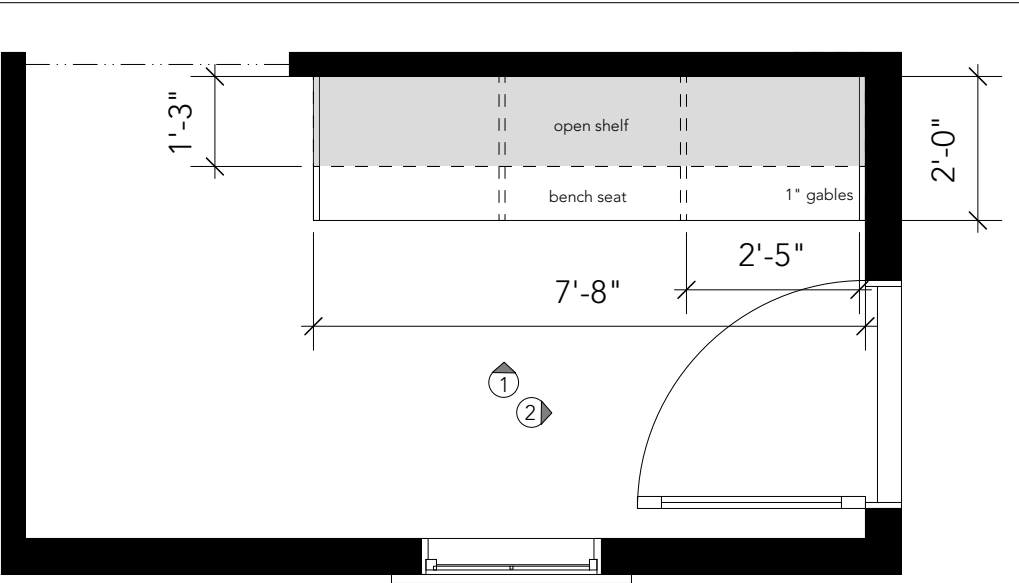


MUDROOM PLAN
SCALE: 3/8" = 1'-0"

HAMPSHIRE MEWS
LOT 4 - LIGHT SCHEME
MUDROOM
03.01.23

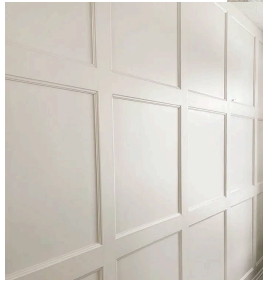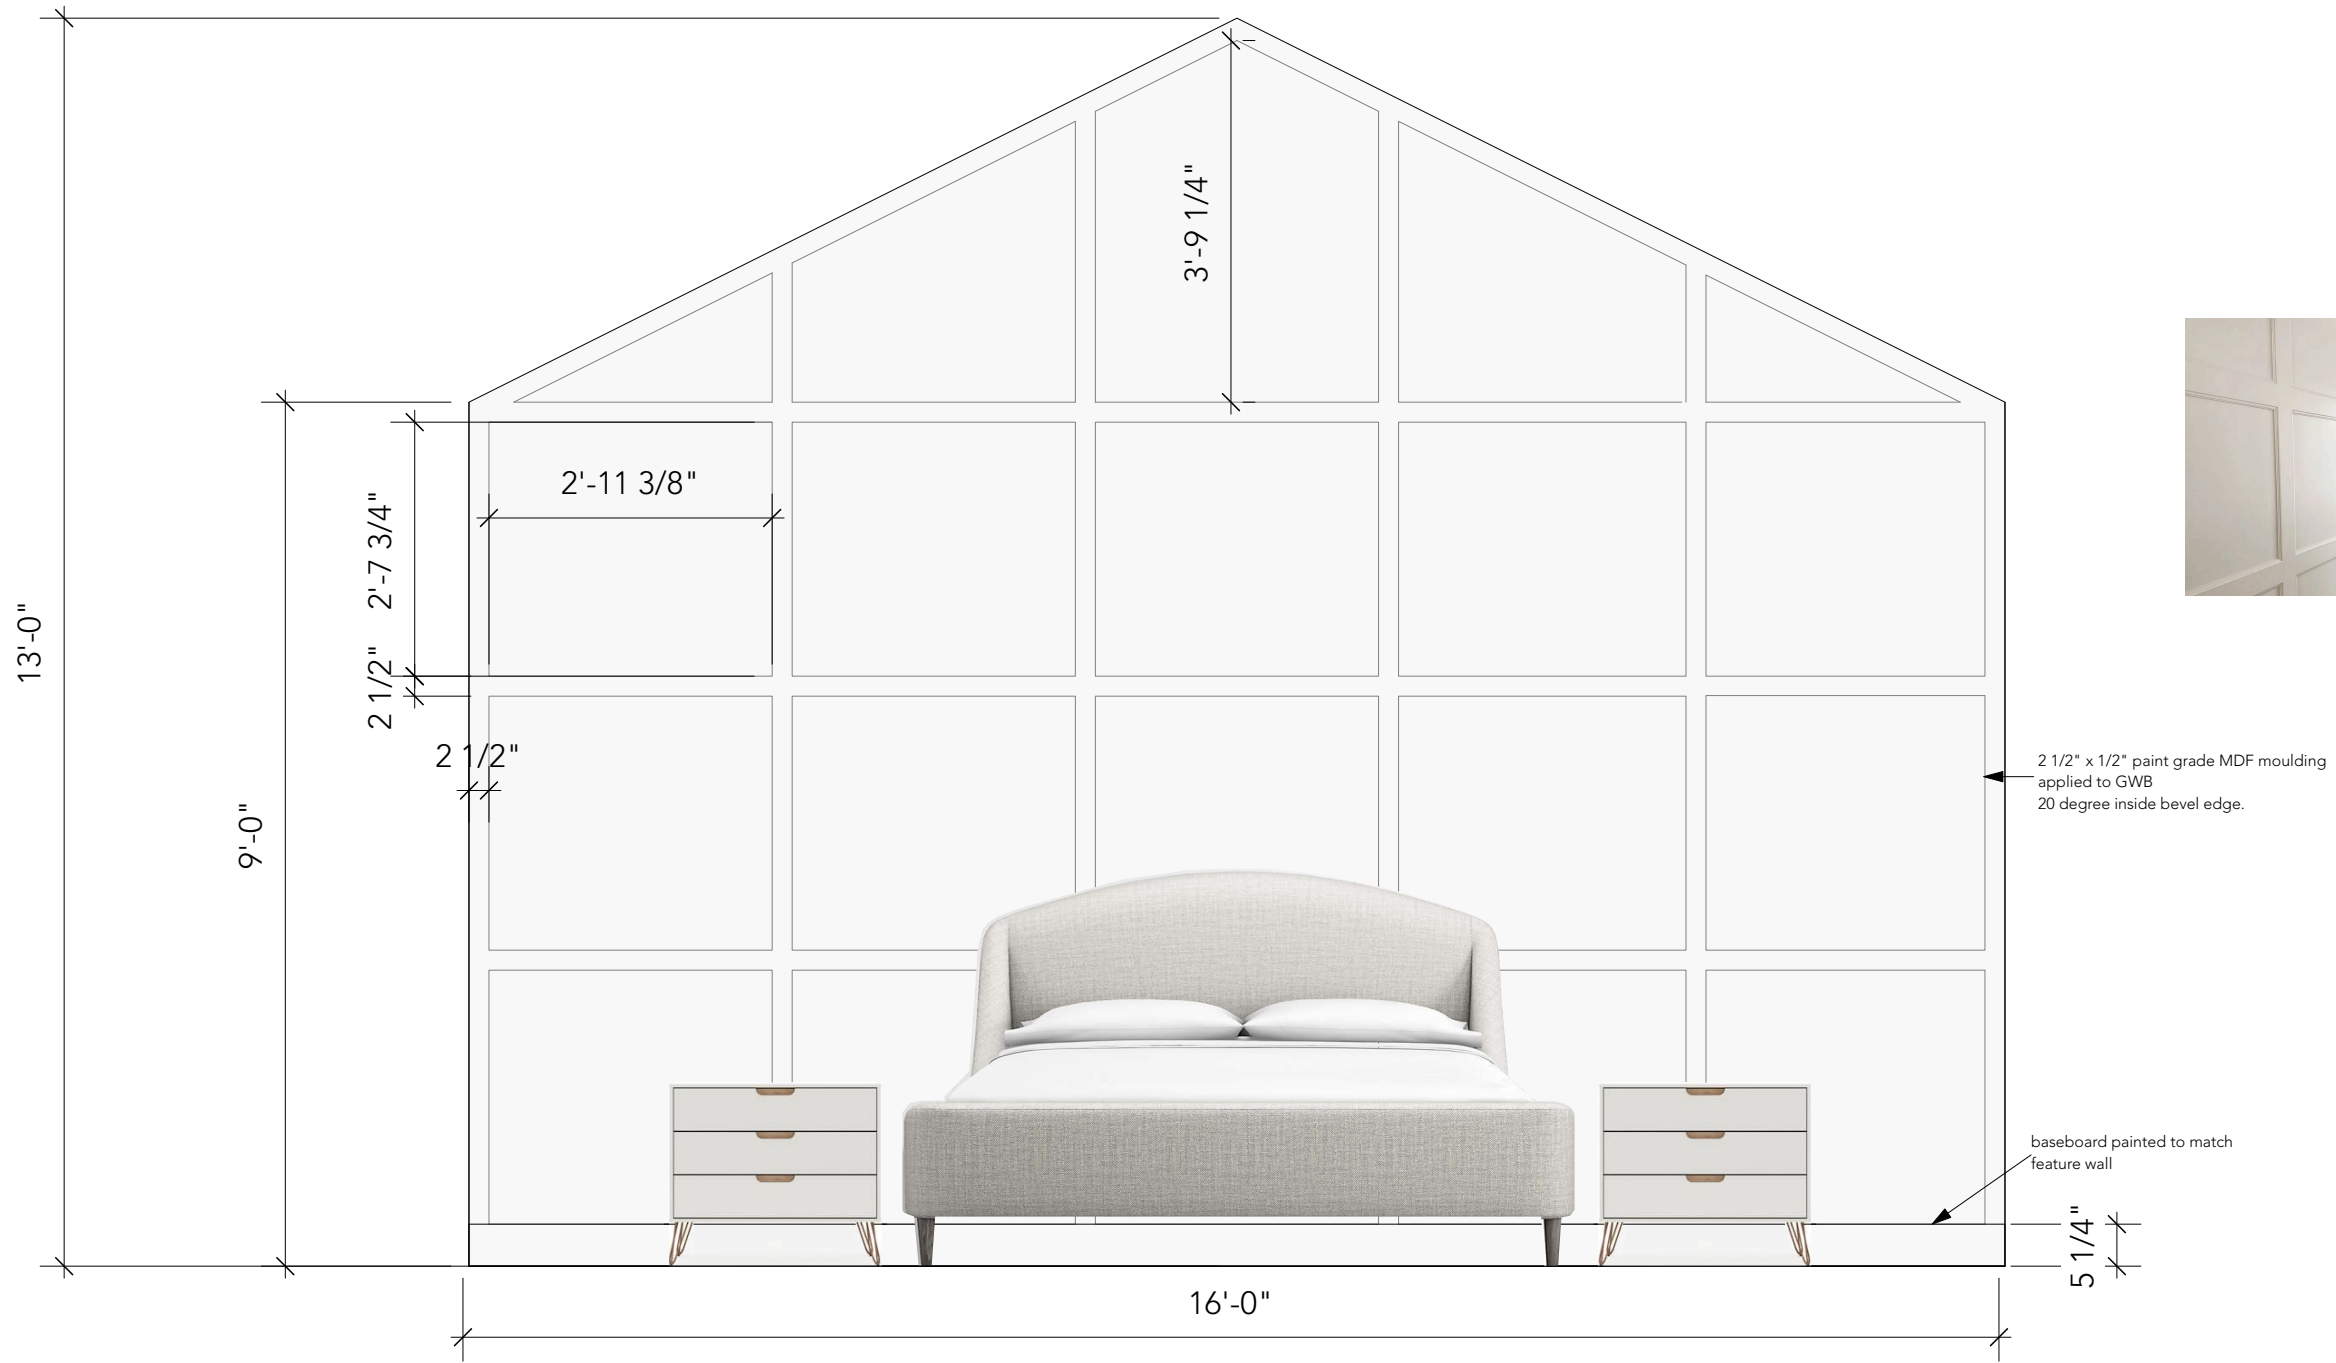


HEADBOARD MOULDING DETAIL

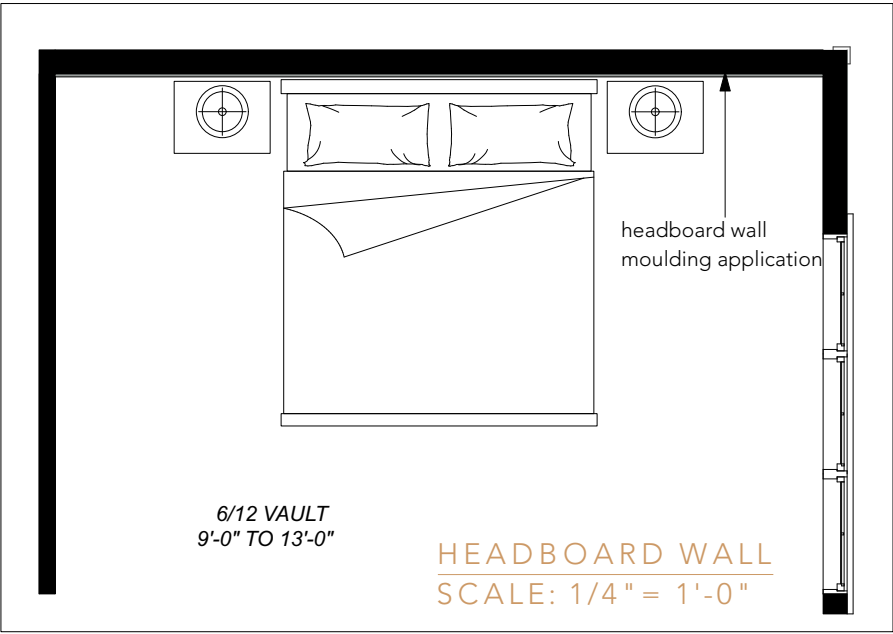




PRIMARY BEDROOM HEADBOARD FEATURE WALL
SCALE: 3/8"=1'-0"

HAMPSHIRE MEWS
LOT 4 - LIGHT SCHEME
PRIMARY BEDROOM
HEADBOARD WALL
03.01.23


ENSUITE ELEVATIONS
SCALE: 1/2" = 1'-0"

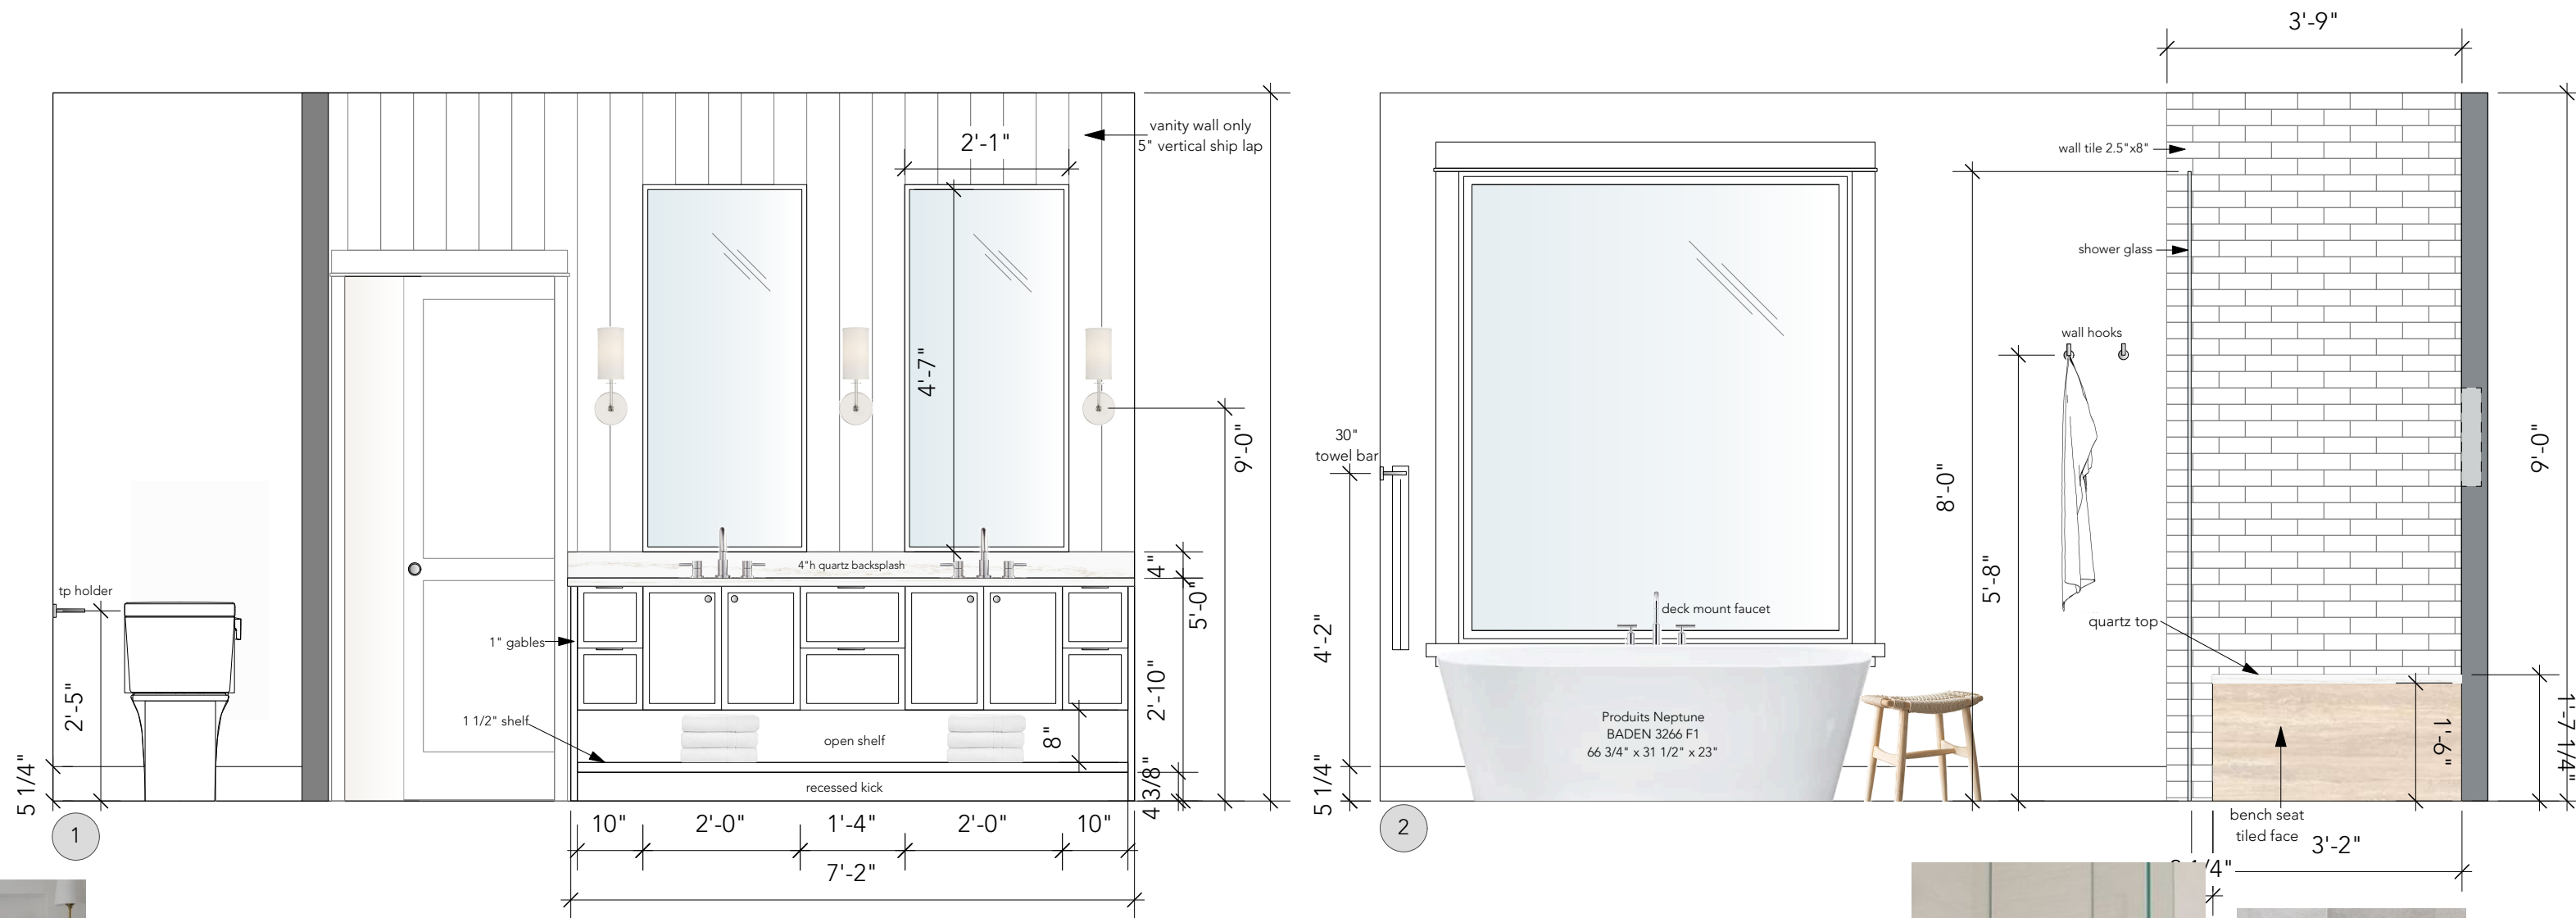

WALL RECESS
12"w x 30"h

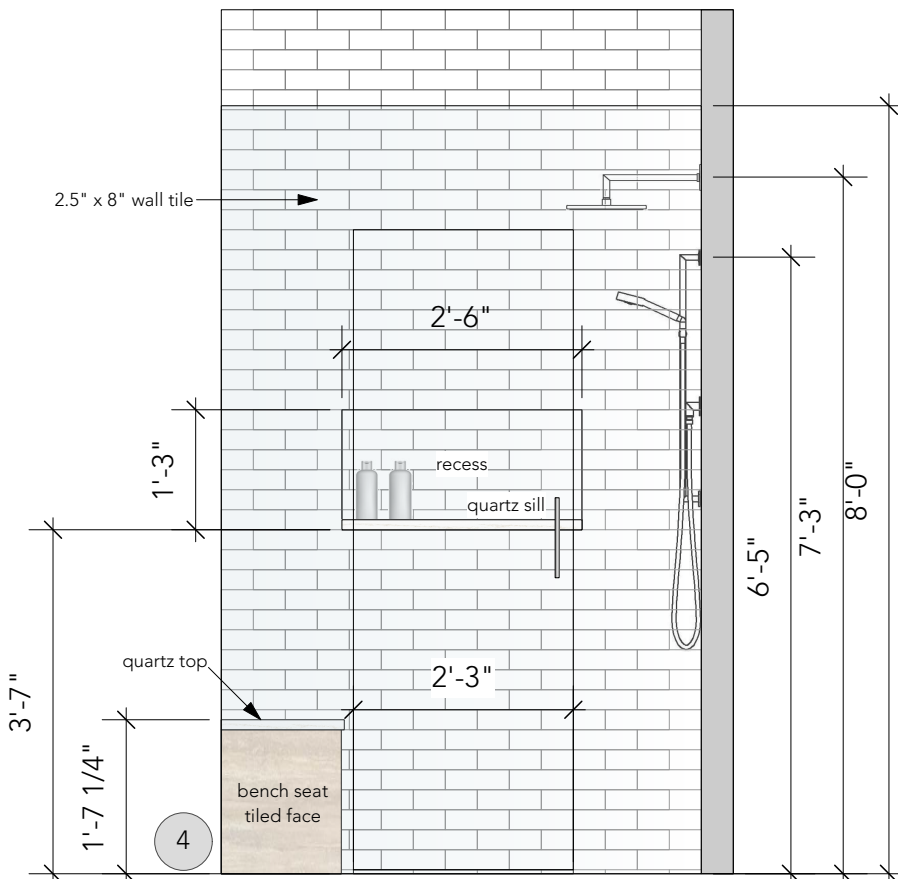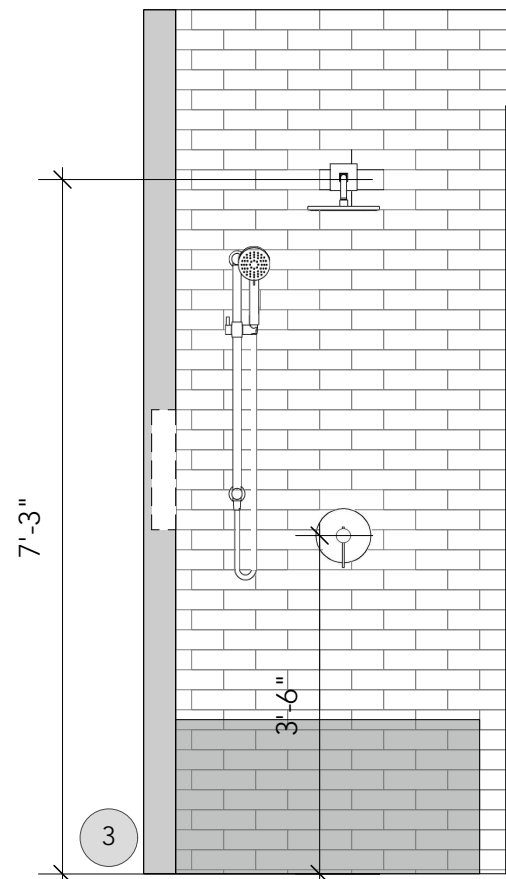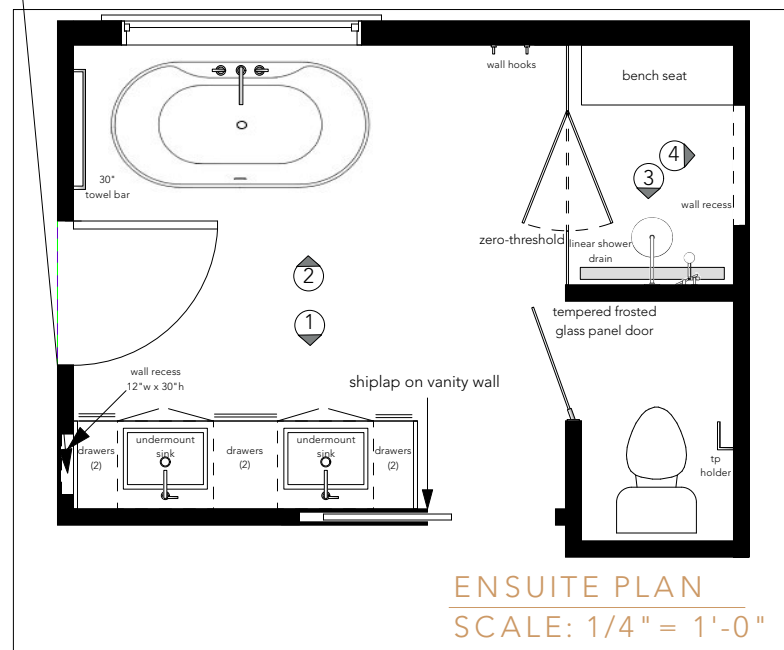





ZERO-THRESHOLD SHOWER

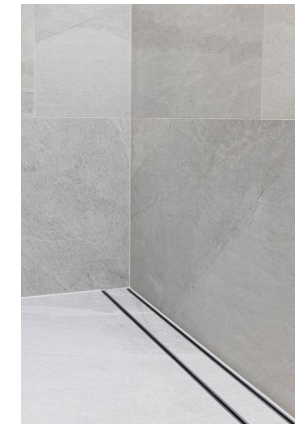

LINEAR SHOWER DRAIN

HAMPSHIRE MEWS
LOT 4 - LIGHT SCHEME
ENSUITE
03.01.23

Page: ID9 of 21

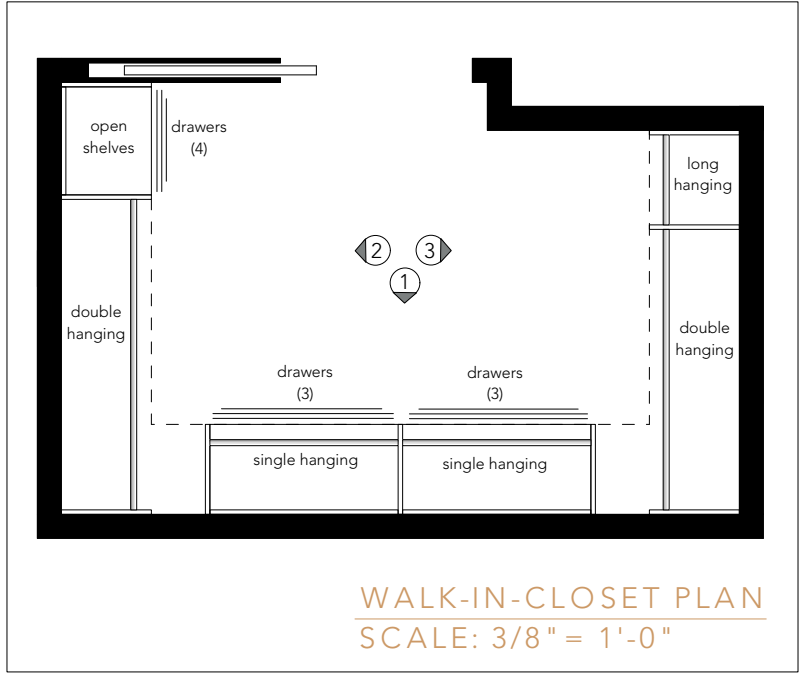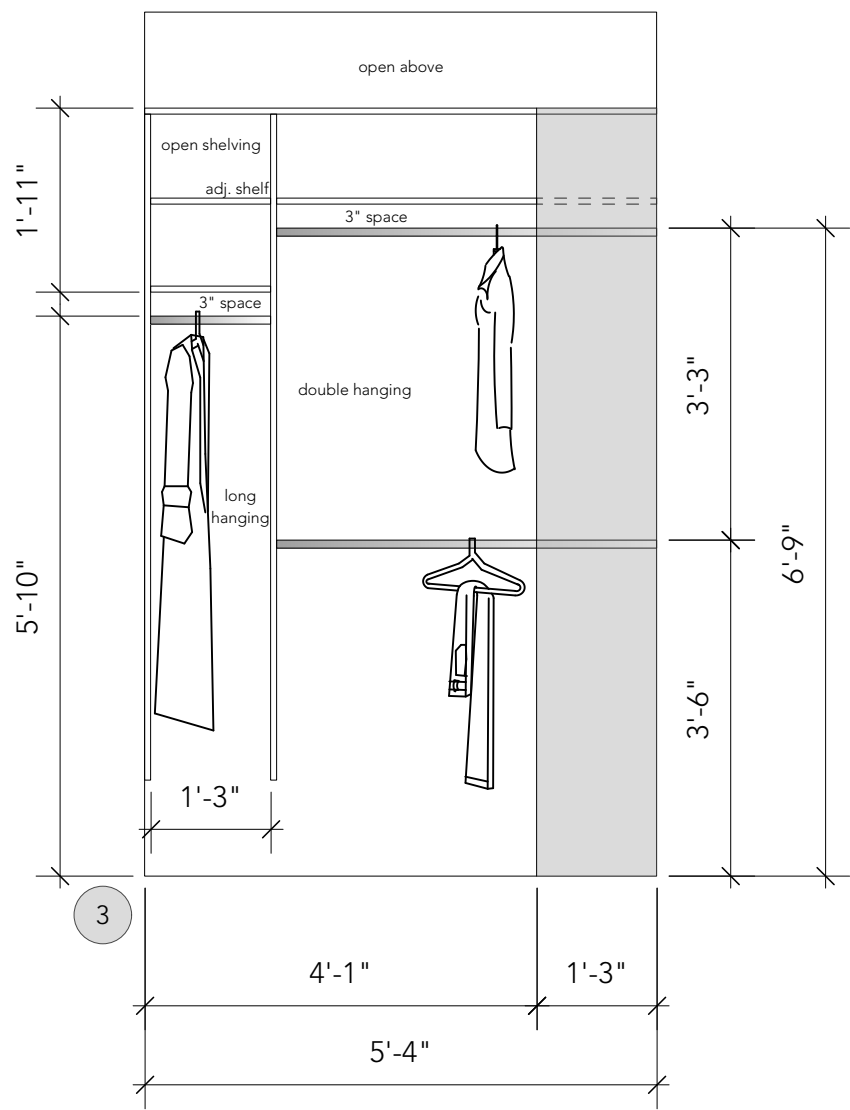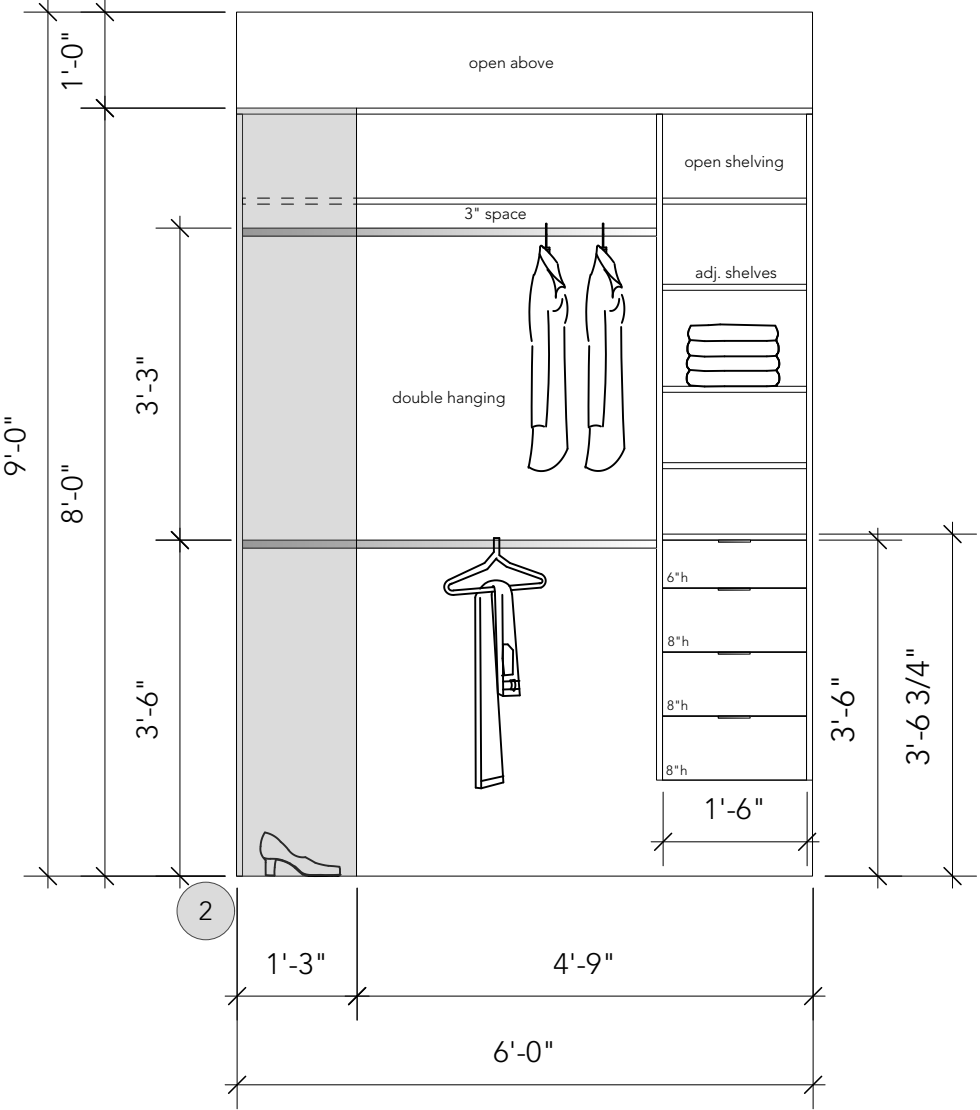
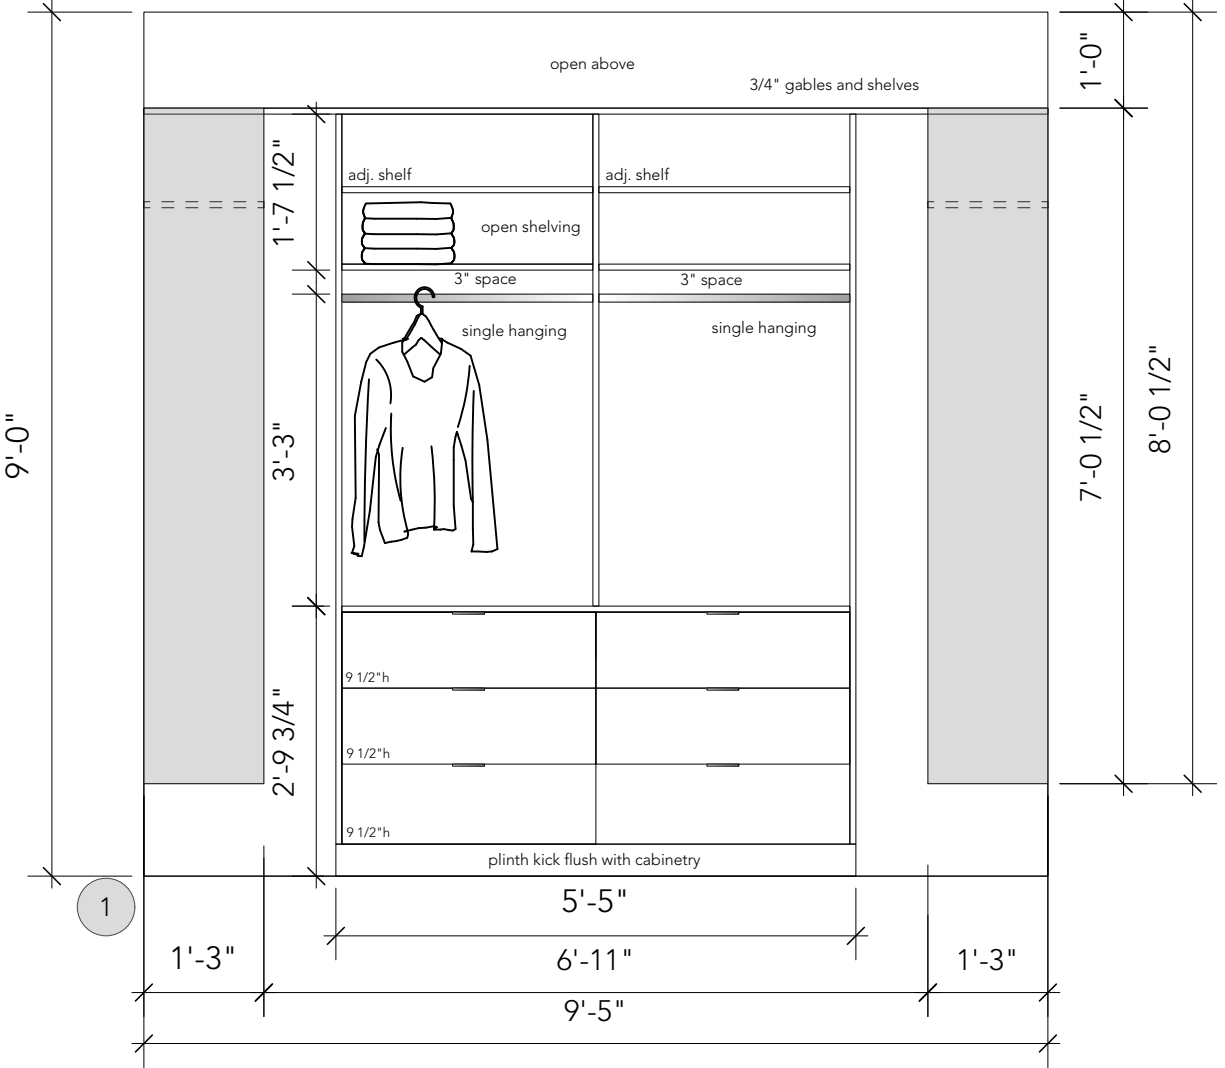


WALK-IN-CLOSET ELEVATIONS
SCALE: 1/2"=1'-0"

HAMPSHIRE MEWS
LOT 4 - LIGHT SCHEME
PRIMARY BEDROOM CLOSET
03.01.23

Technical drawing of a vanity unit with a mirror, sink, and door. The drawing includes the following dimensions and labels:

- Overall Dimensions:**
 - Width: 5'-0"
 - Height: 9'-0"
- Vanity Unit Dimensions:**
 - Width: 5'-0" (divided into 1'-2 1/4", 2'-6", and 1'-2 1/4")
 - Height: 2'-10"
 - Top Section Height: 4'-6"
 - Bottom Section Height: 3'-2"
 - Recessed Kick: 2'-6"
- Mirror Dimensions:**
 - Width: 4'-0"
 - Height: 3'-0"
- Sink and Backsplash:**
 - Sink: 1 1/4" quartz
 - Backsplash: 4" h quartz backsplash
- Labels and Callouts:**
 - 3/4" frame, painted to match vanity
 - hand towel bar
 - 3/4" filler
 - 3/4" end panel
 - recessed kick
- Door Dimensions:**
 - Width: 3'-6"
- Lighting:** Three light fixtures are shown above the mirror.

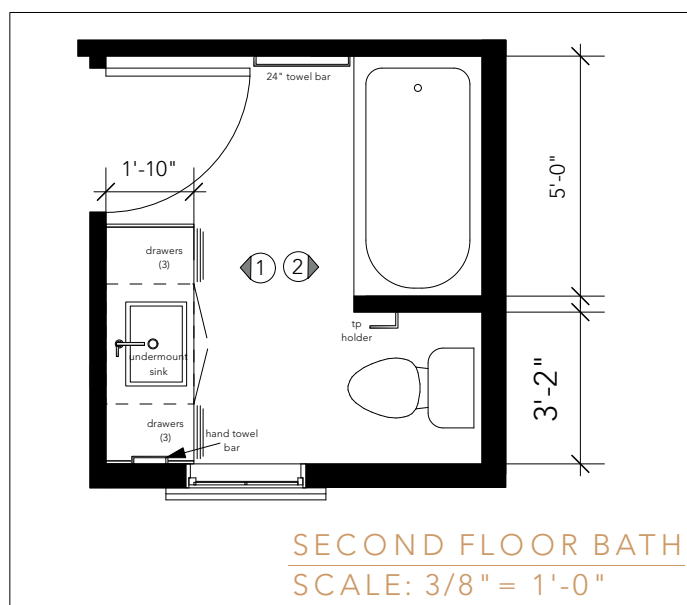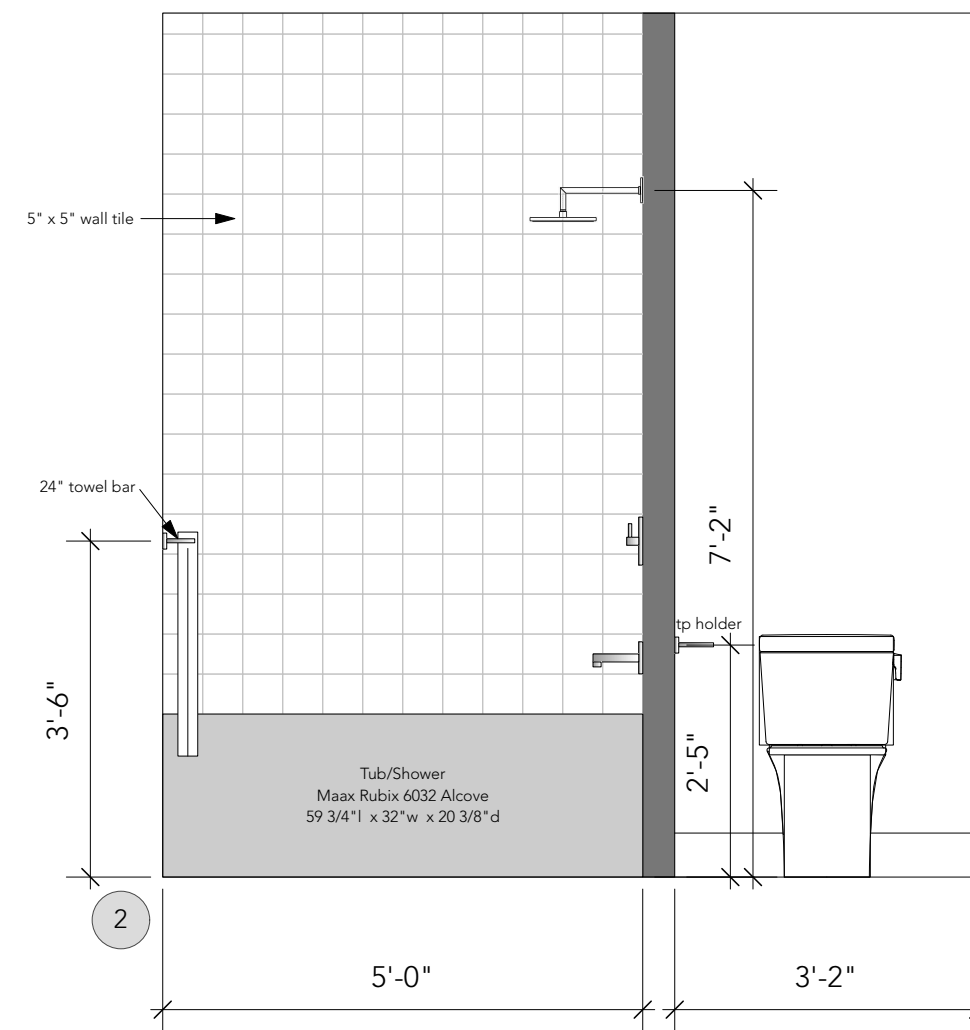

HAMPSHIRE MEWS
LOT 4 - LIGHT SCHEME
SECOND FLOOR BATH
03.01.23

Page: ID11 of 21



The logo for Kwi Design features the word "Kwi" in a large, elegant, brown cursive script. To the right of "Kwi", the word "DESIGN" is written in a smaller, brown, all-caps sans-serif font.

Kwi
DESIGN


7174 West Saanich Road
Brentwood Bay, BC
250.652.6488
kwidesign.ca



INSPIRATION

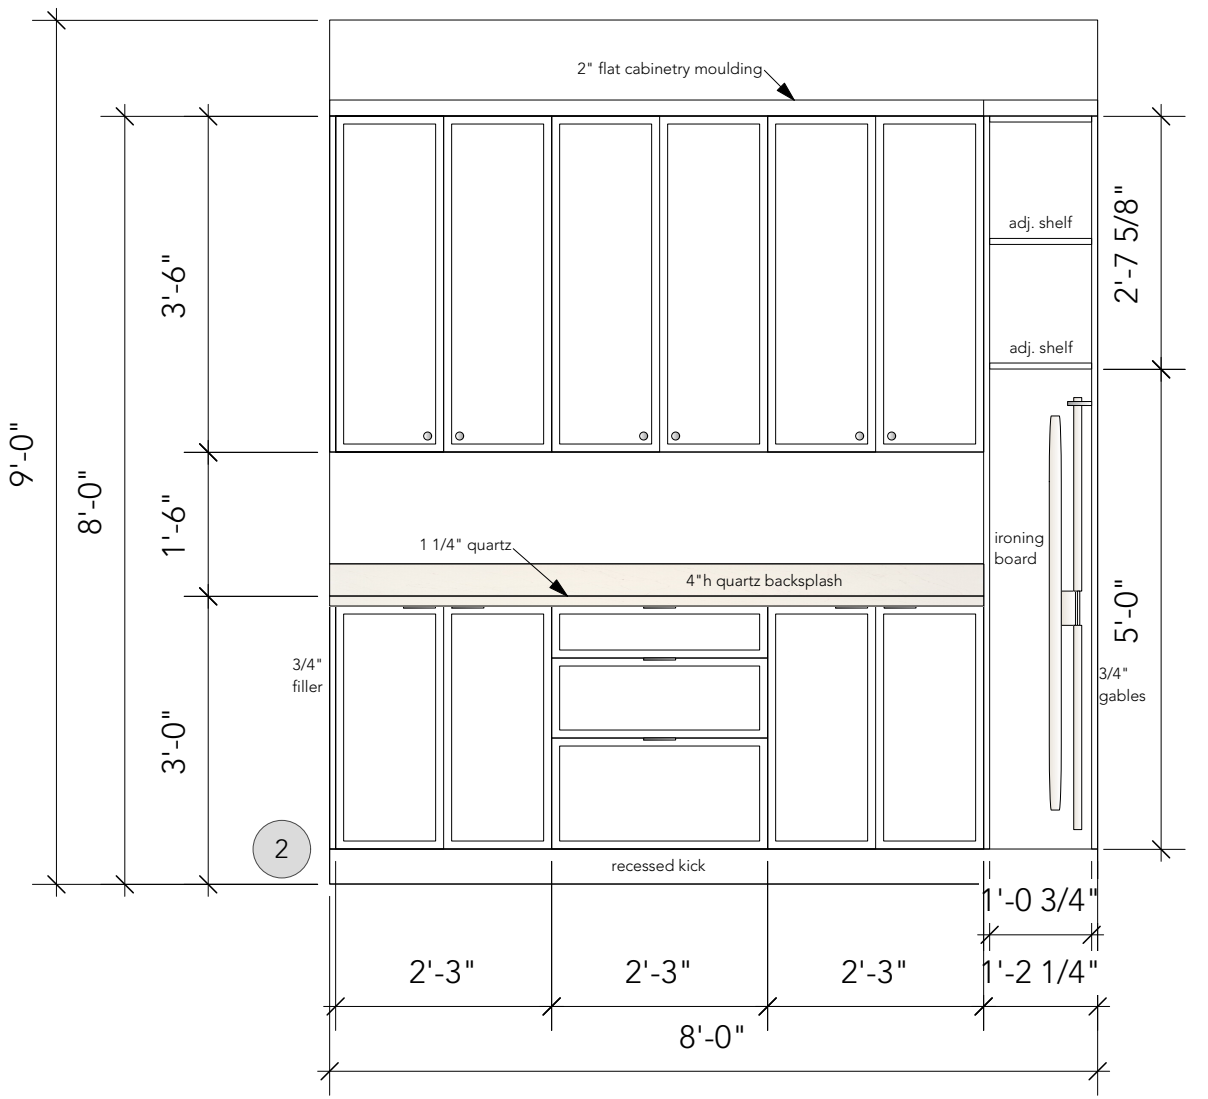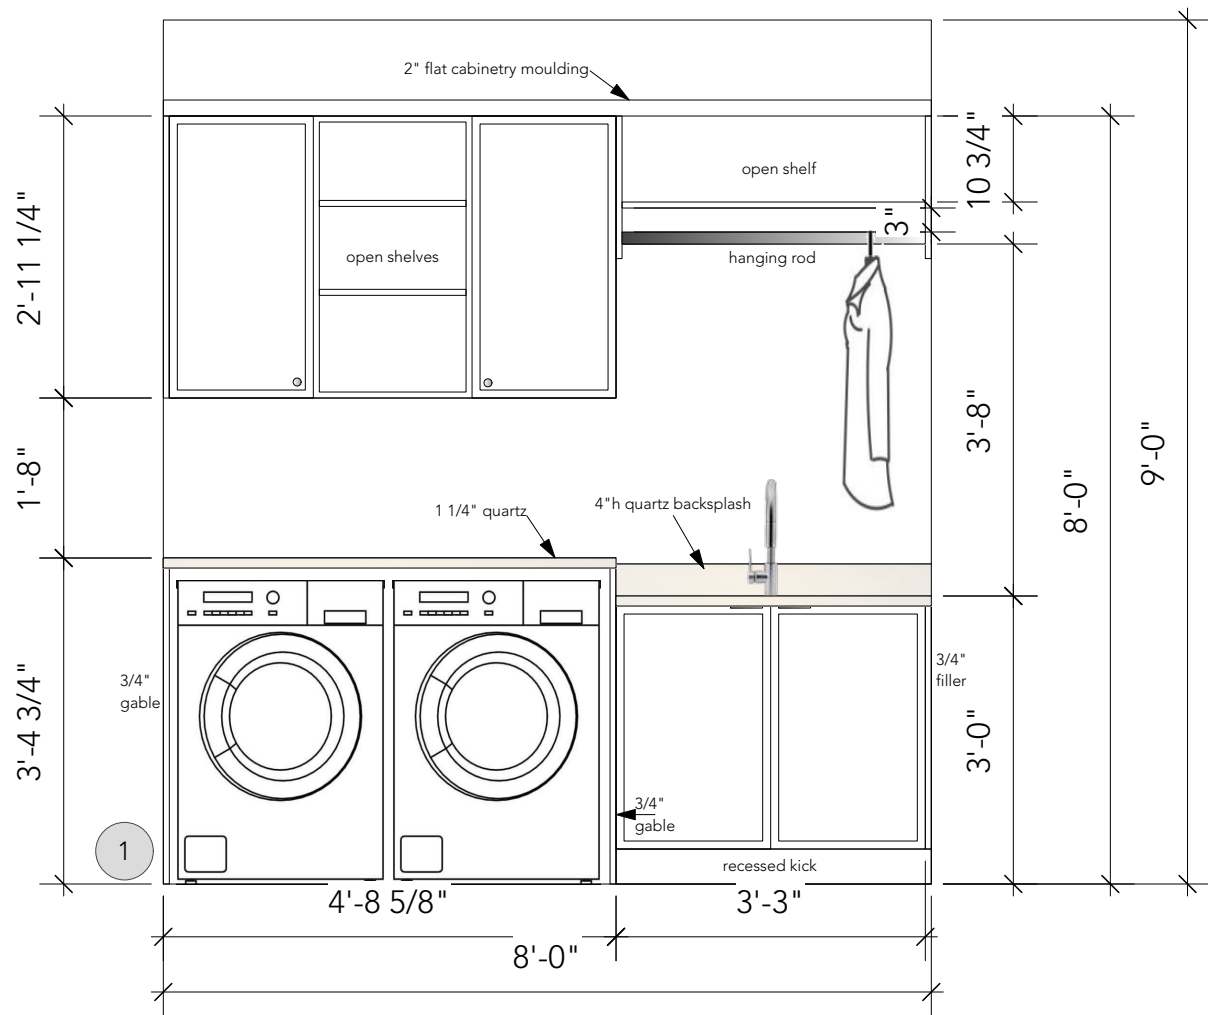

LAUNDRY ELEVATIONS
SCALE: 1/2"=1'-0"

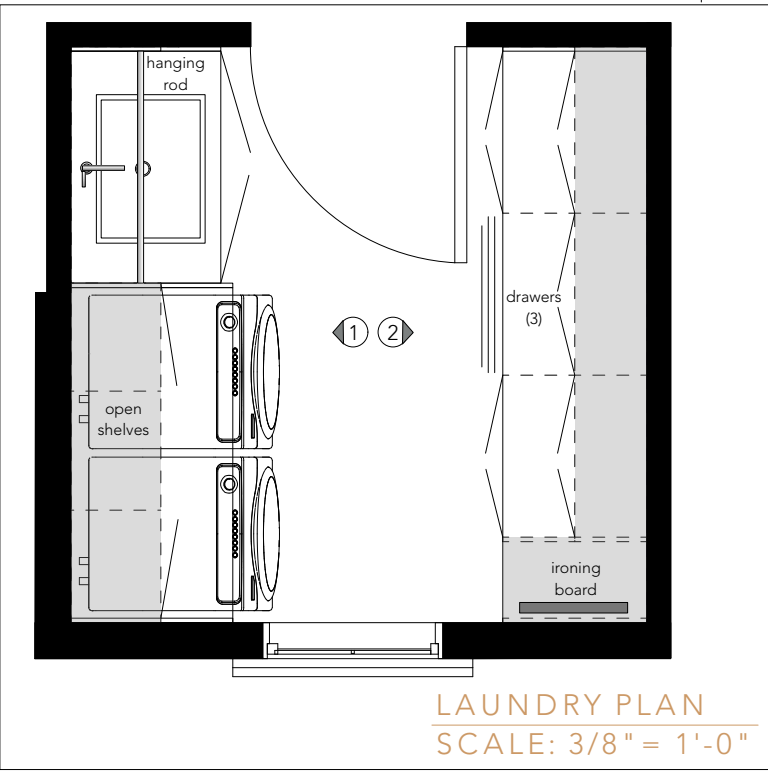


HAMPSHIRE MEWS
LOT 4 - LIGHT SCHEME
LAUNDRY ROOM
03.01.23




INSPIRATION

LOWER FLOOR BAR ELEVATION
SCALE: 1/2" = 1'-0"

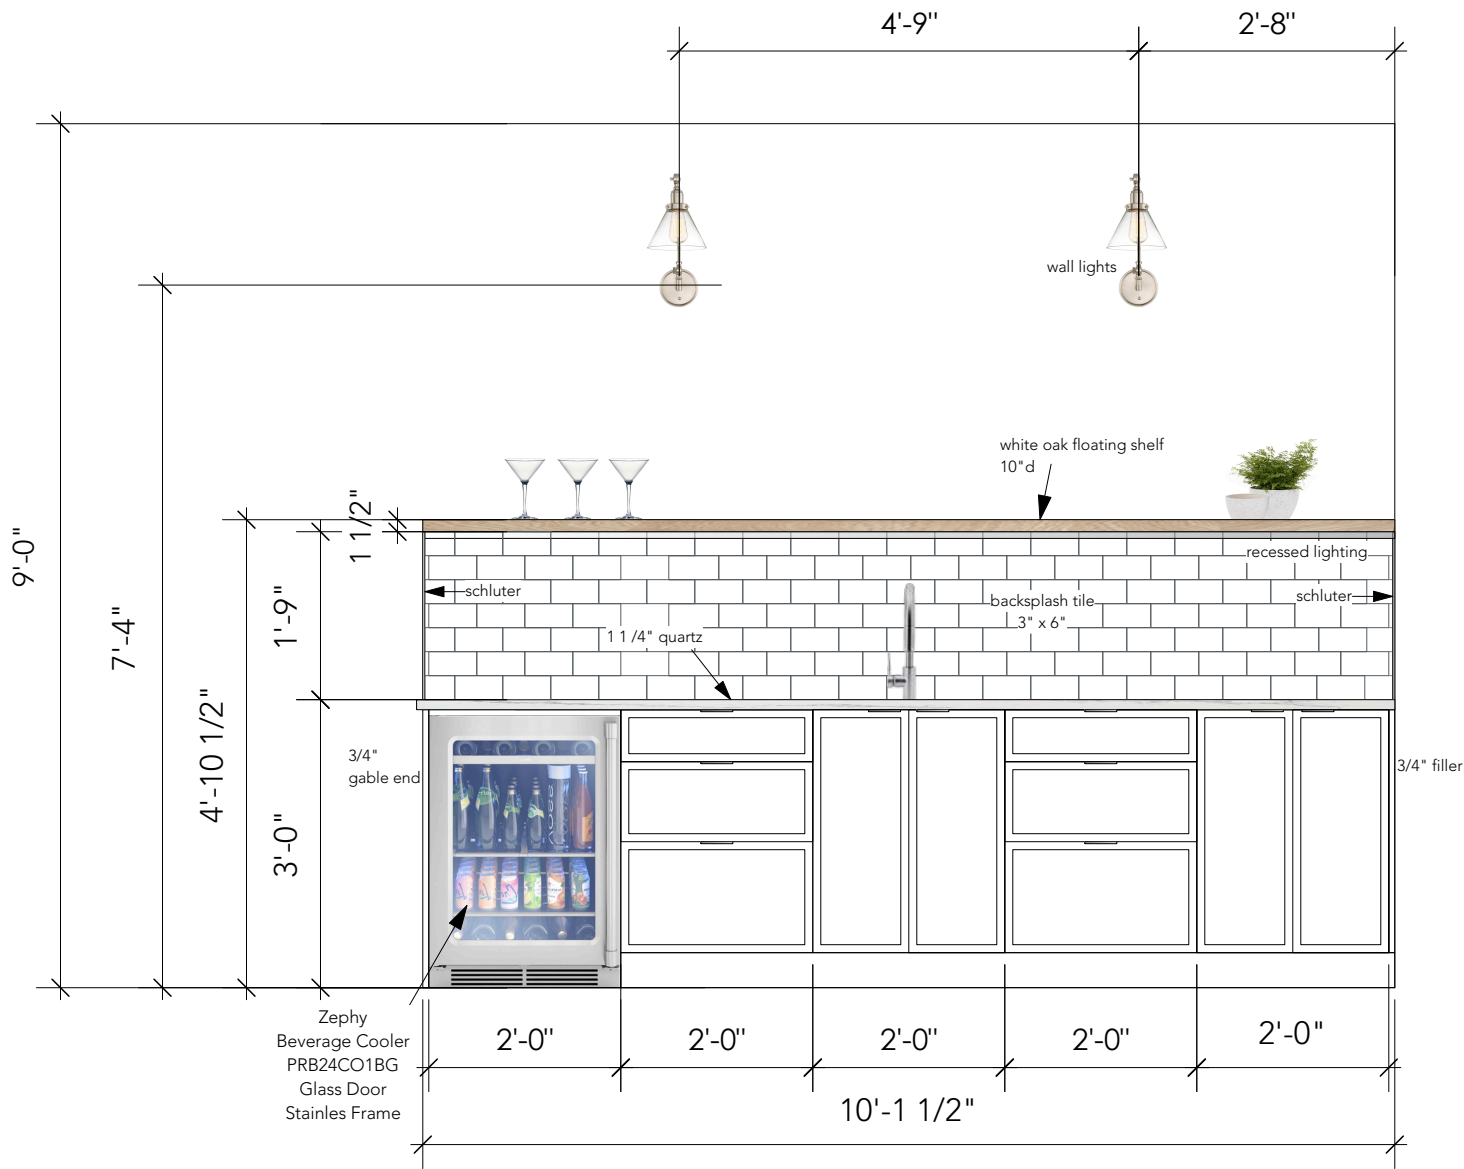



LOWER FLOOR BAR ELEVATION
SCALE: 1/2"=1'-0"

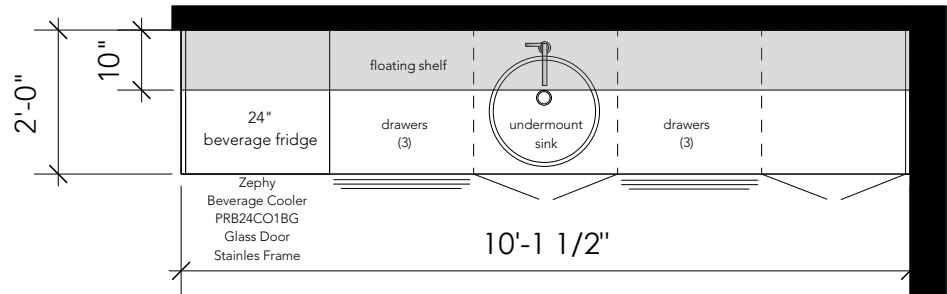


CABINETRY PLAN
SCALE: 3/8" = 1'-0"

HAMPSHIRE MEWS
LOT 4 - LIGHT SCHEME
LOWER FLOOR BAR
03.01.23

LOWER FLOOR BATH ELEVATIONS
SCALE: 1/2" = 1'-0"

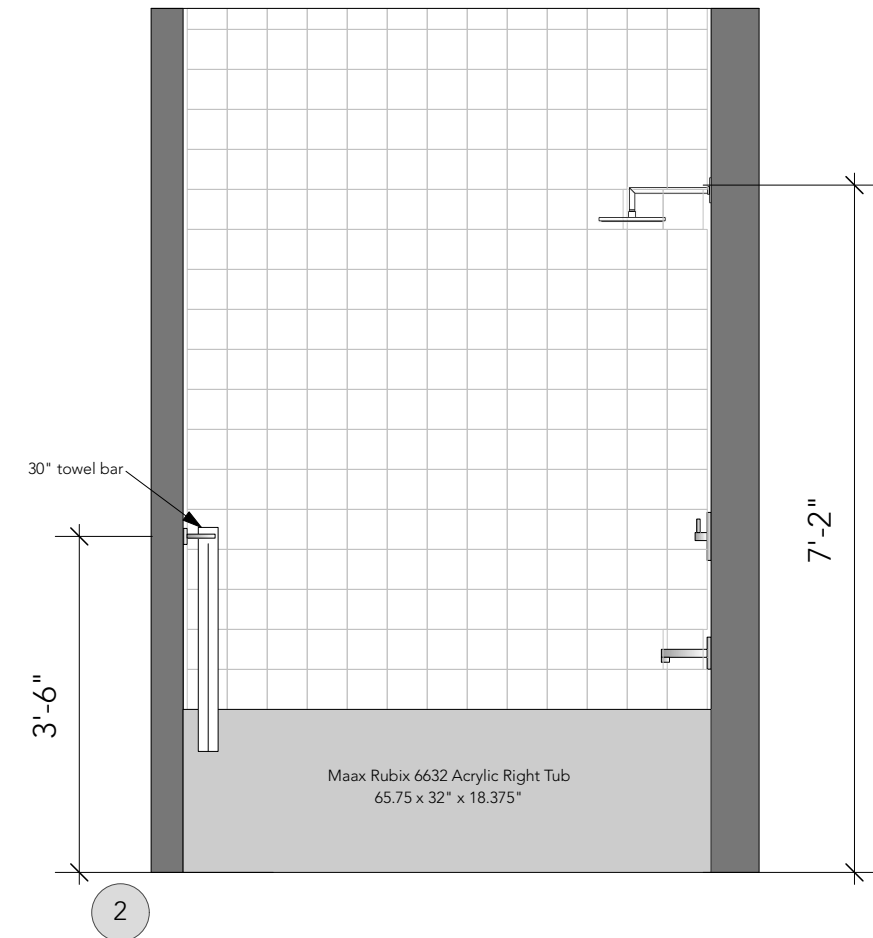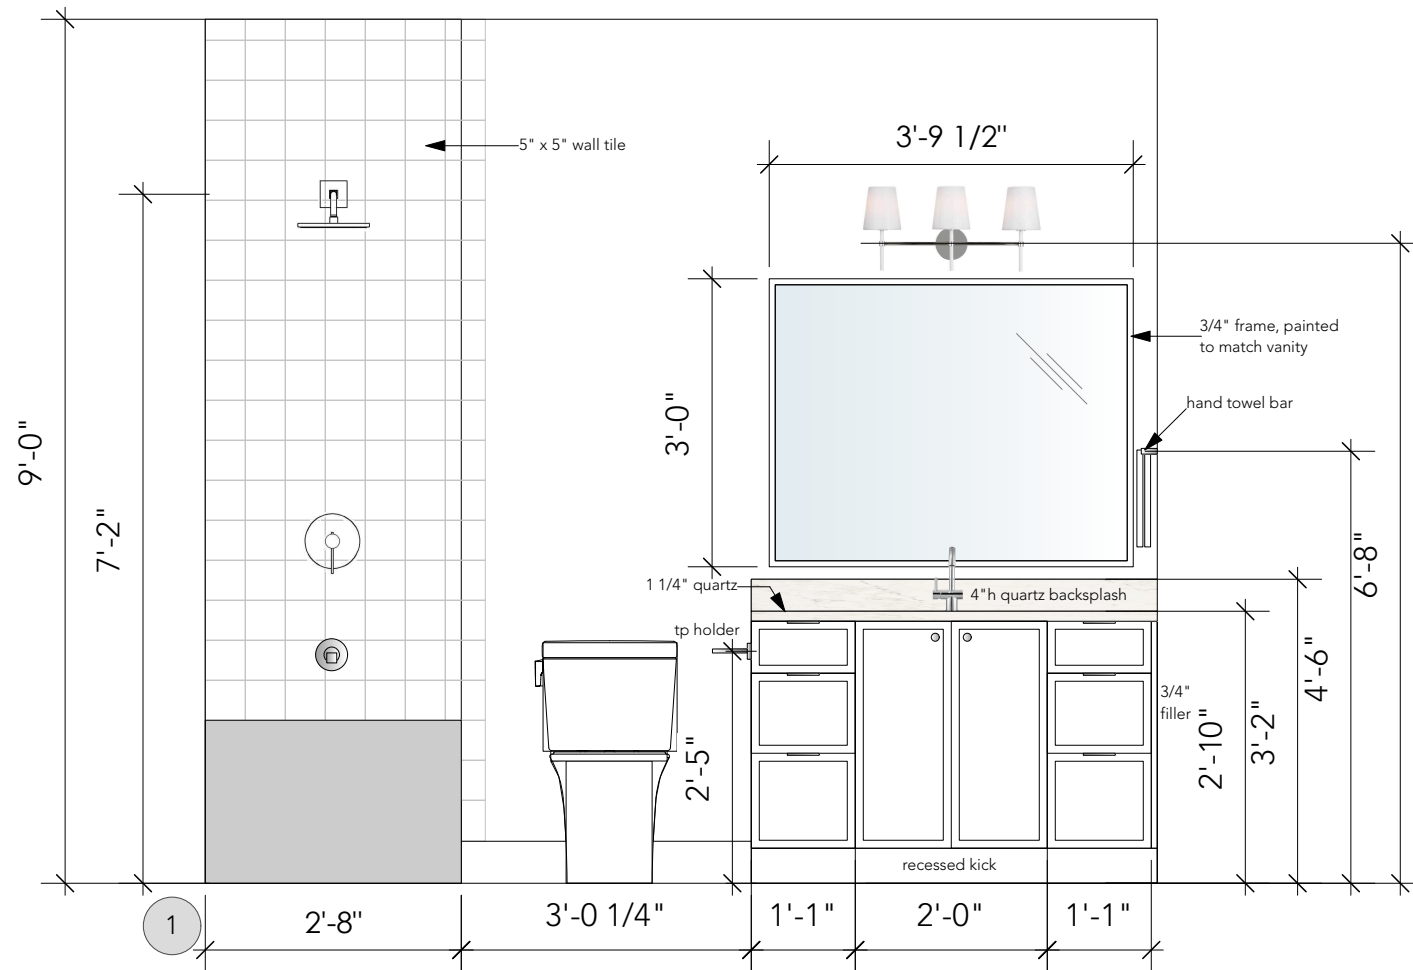


LOWER FLOOR BATHROOM ELEVATIONS
SCALE: 1/2" = 1'-0"

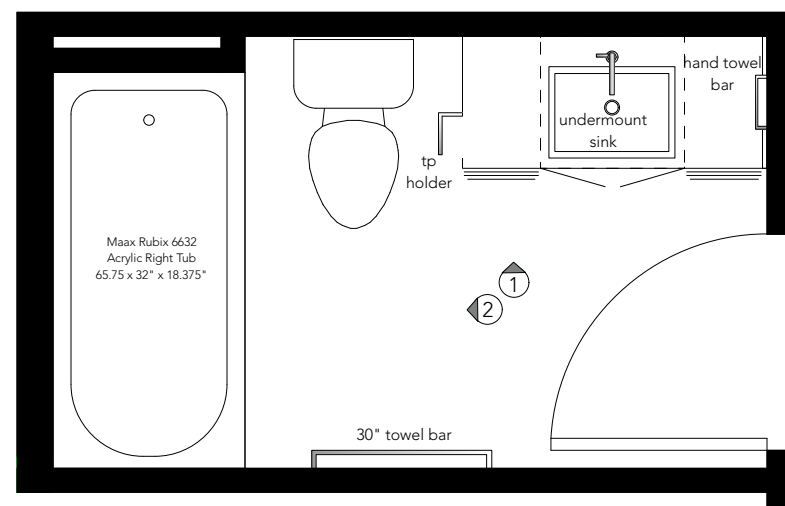

LOWER FLOOR BATH
SCALE: 3/8" = 1'-0"

HAMPSHIRE MEWS
LOT 4 - LIGHT SCHEME
LOWER FLOOR BATH
03.01.23

Page: ID14 of 21

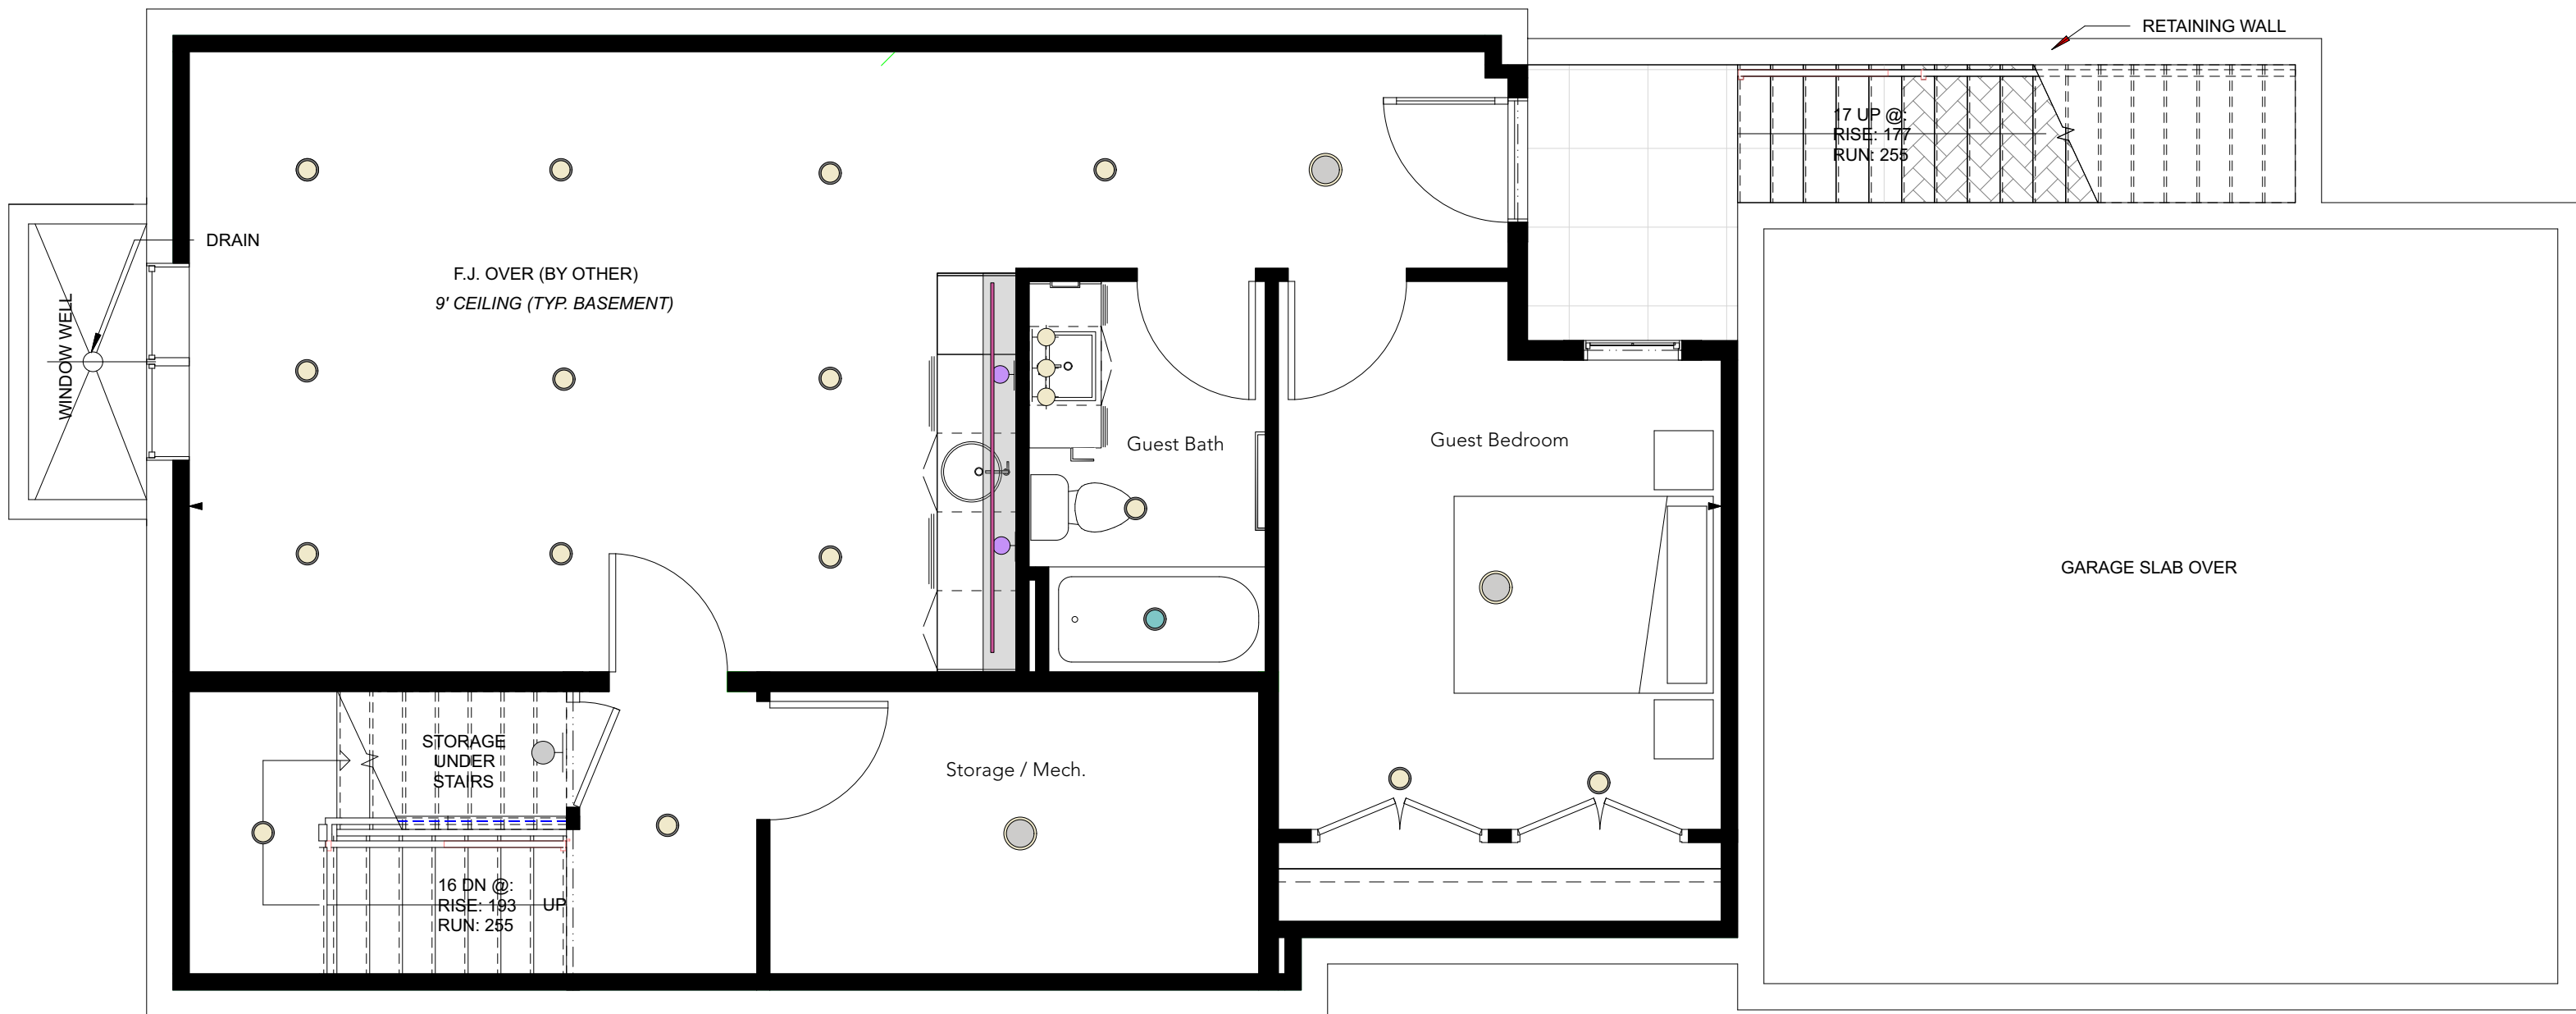

LIGHTING LEGEND			
	SURFACE MOUNT		VANITY WALL LIGHT
	RECESSED POT LIGHTS		WALL SCONCE
	RECESSED UNDER CABINET LIGHTS		PENDANT LIGHT
	WET RATED RECESSED POT LIGHT		UTILITY LIGHT

HAMPSHIRE MEWS
LOT 4 - LIGHT SCHEME
BASEMENT PLAN
LIGHTING PLAN
SCALE: 1/4" = 1'-0"
03.01.23

LIGHTING LEGEND

 SURFACE MOUNT

 RECESSED POT LIGHTS

 UNDER CABINET LED STRIP LIGHT


 WET RATED RECESSED POT LIGHT

 VANITY WALL LIGHT

 WALL SCONCE

 PENDANT LIGHT

 UTILITY LIGHT

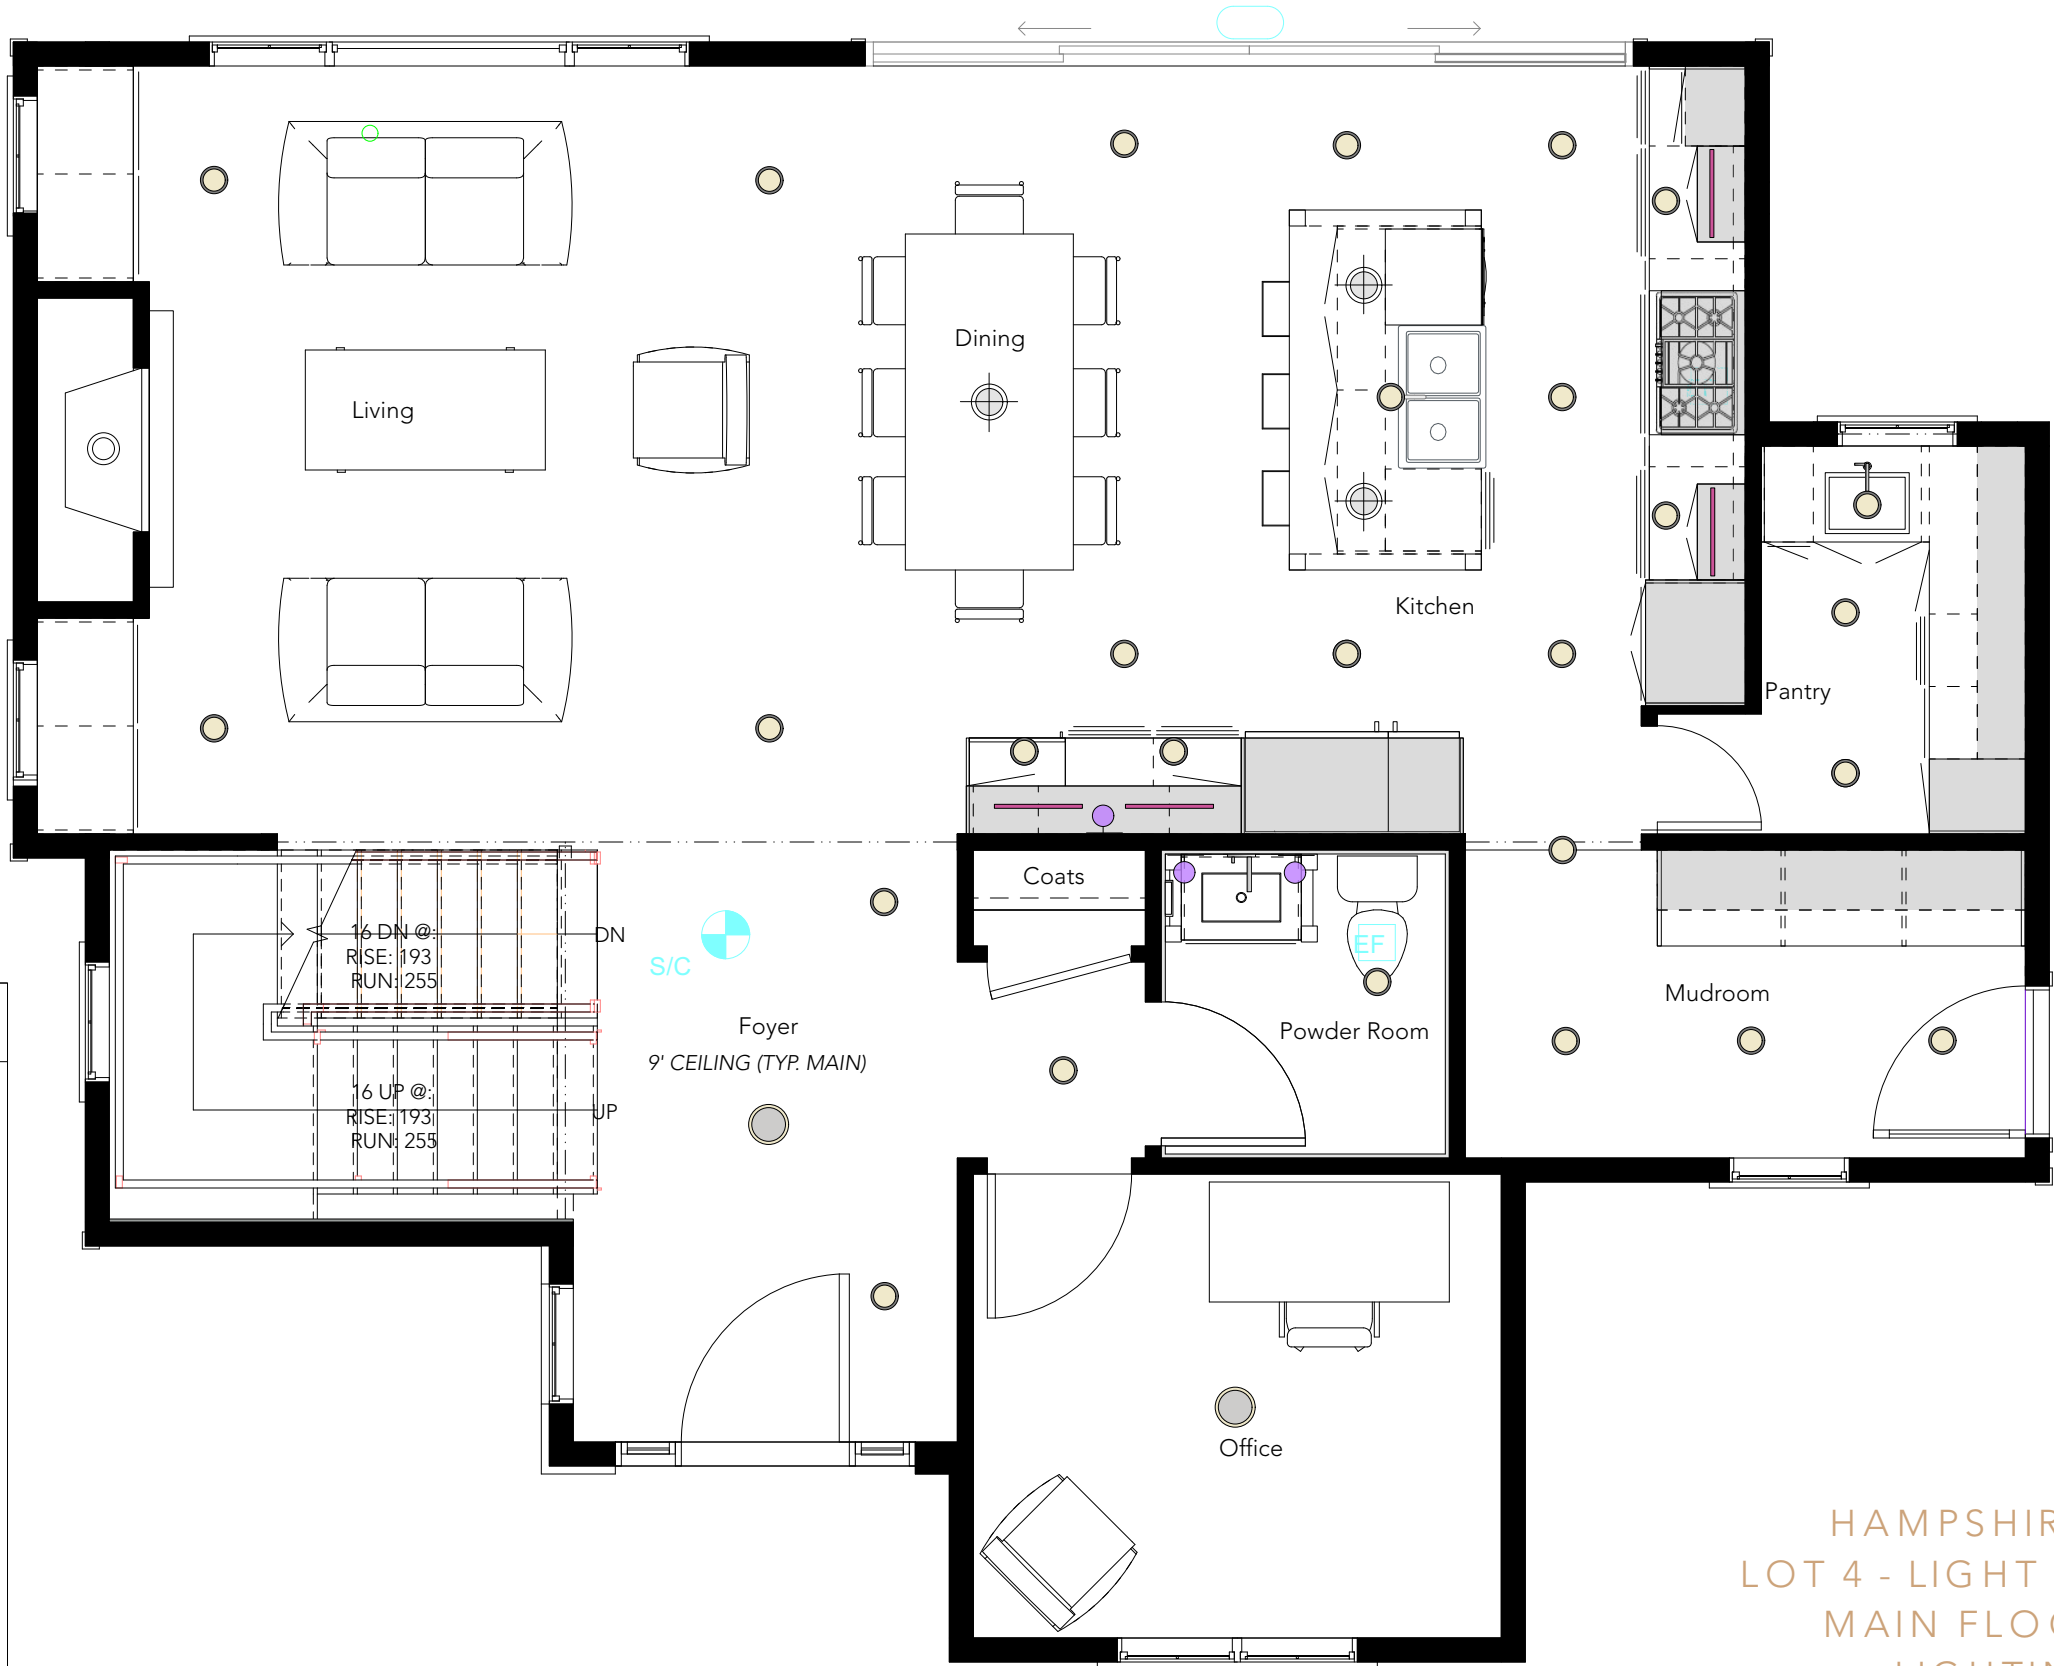

HAMPSHIRE MEWS
LOT 4 - LIGHT SCHEME
MAIN FLOOR PLAN
LIGHTING PLAN
SCALE: 1/4" = 1'-0"
03.01.23

LIGHTING LEGEND



SURFACE MOUNT



RECESSED POT LIGHTS



RECESSED UNDER CABINET LIGHTS



WET RATED RECESSED POT LIGHT



VANITY WALL LIGHT




WALL SCONCE




PENDANT LIGHT



UTILITY LIGHT

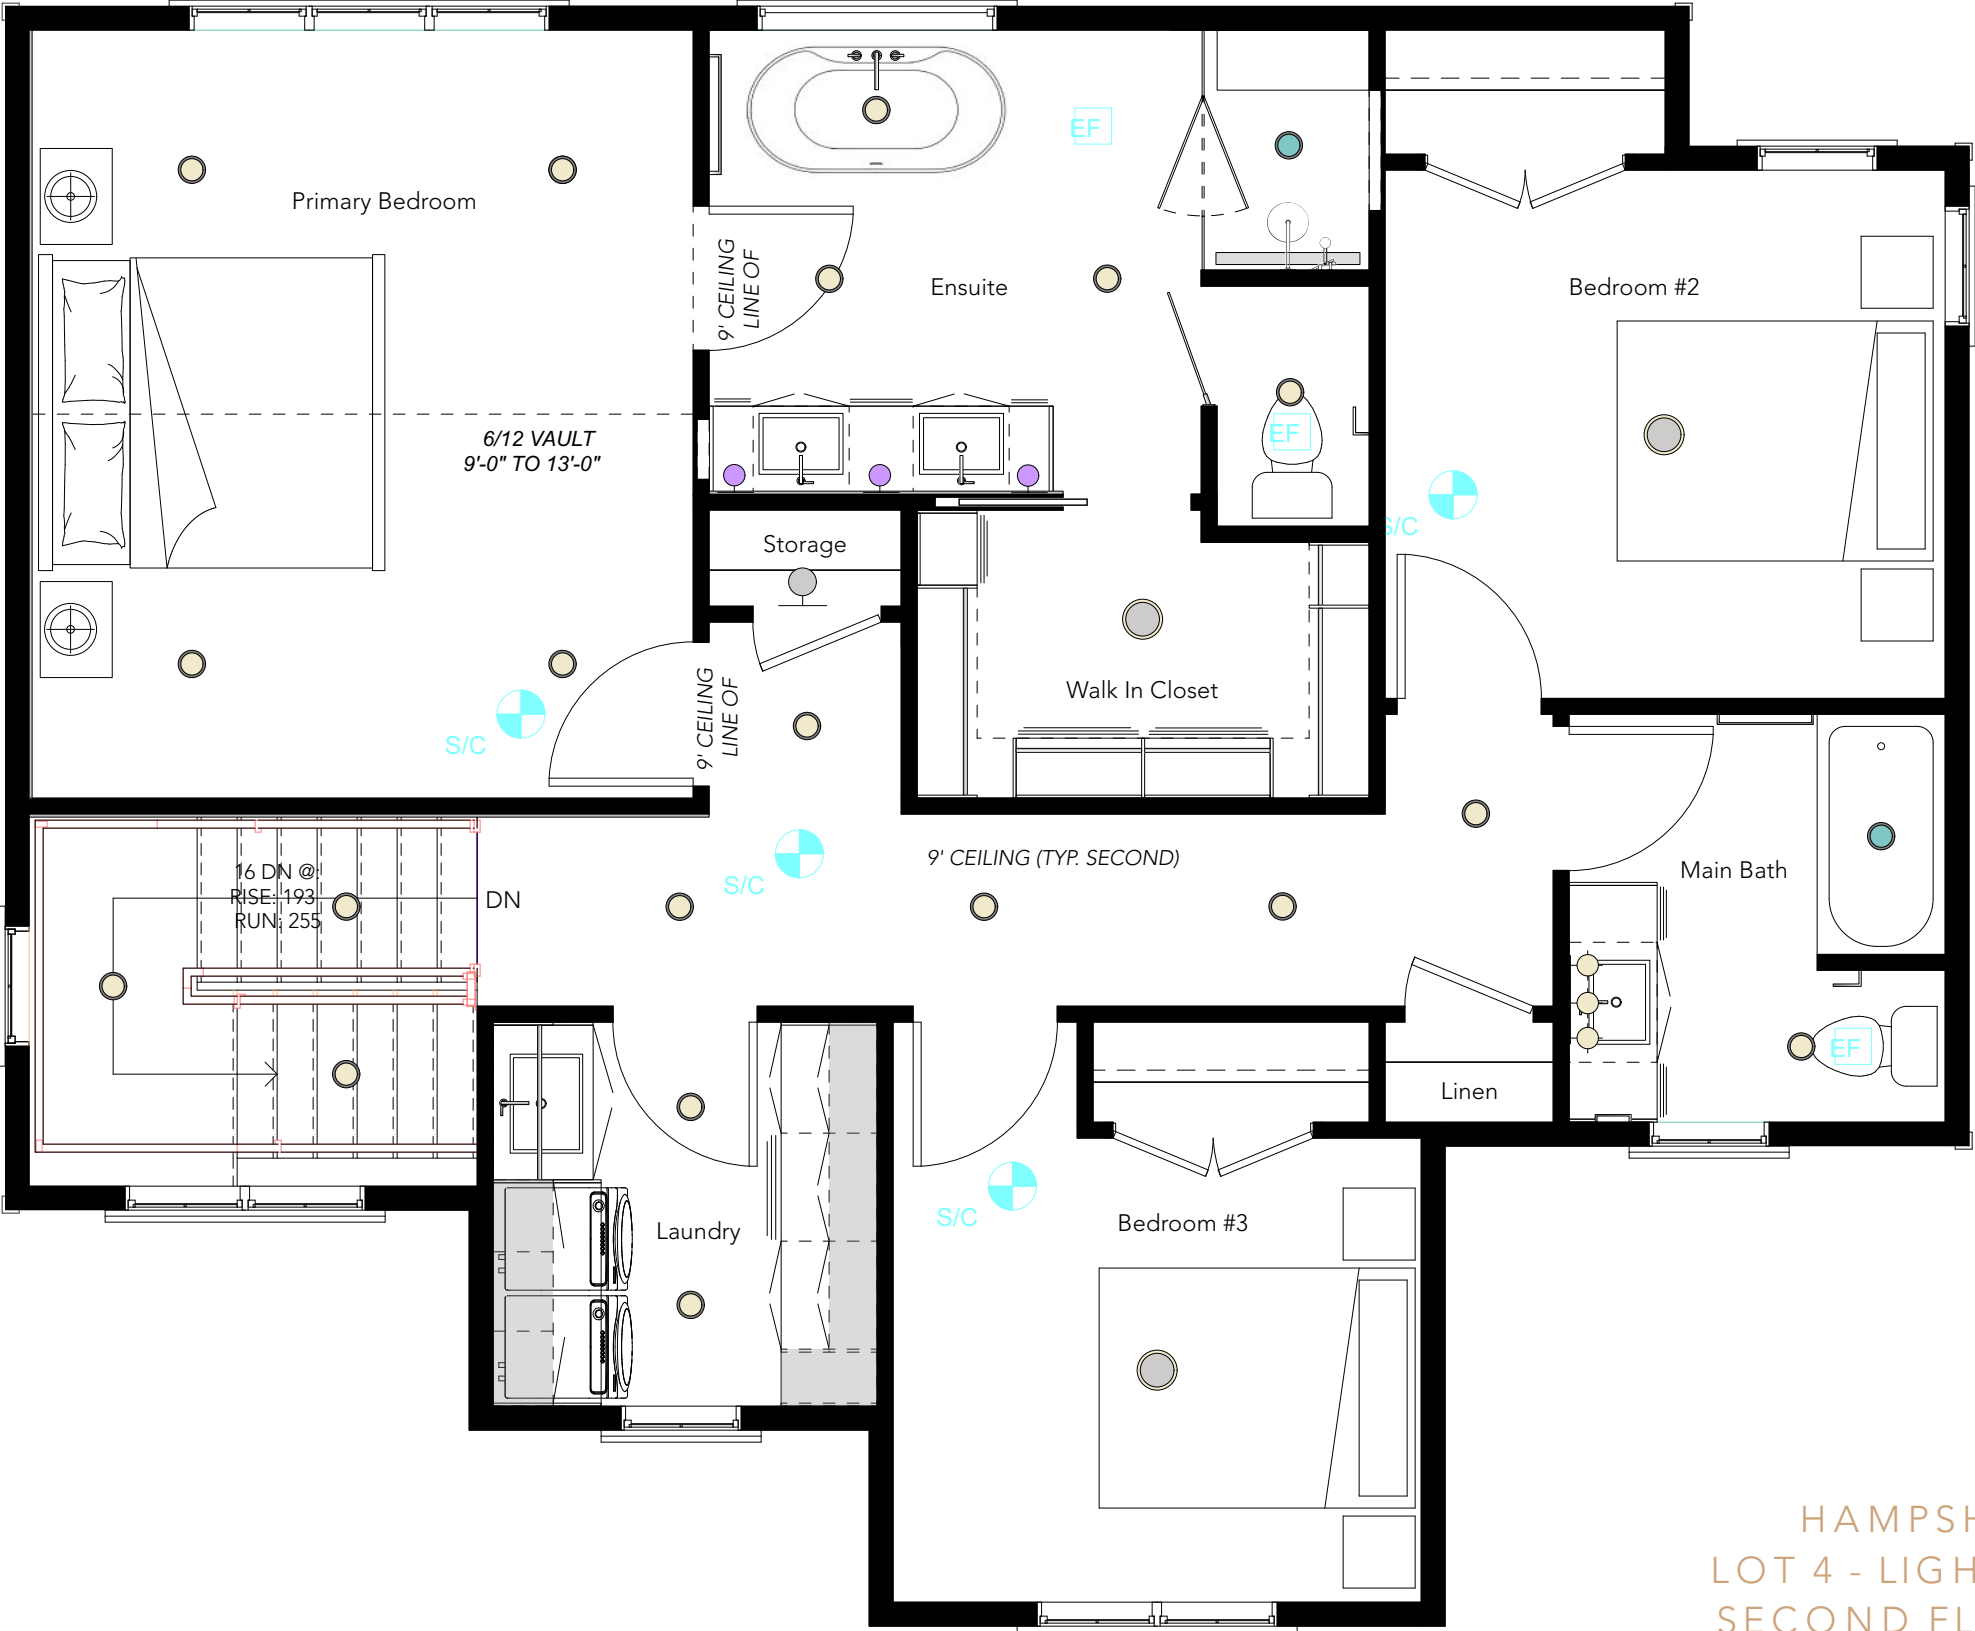



HAMPSHIRE MEWS
LOT 4 - LIGHT SCHEME
SECOND FLOOR PLAN
LIGHTING PLAN
SCALE: 1/4" = 1'-0"
03.01.23

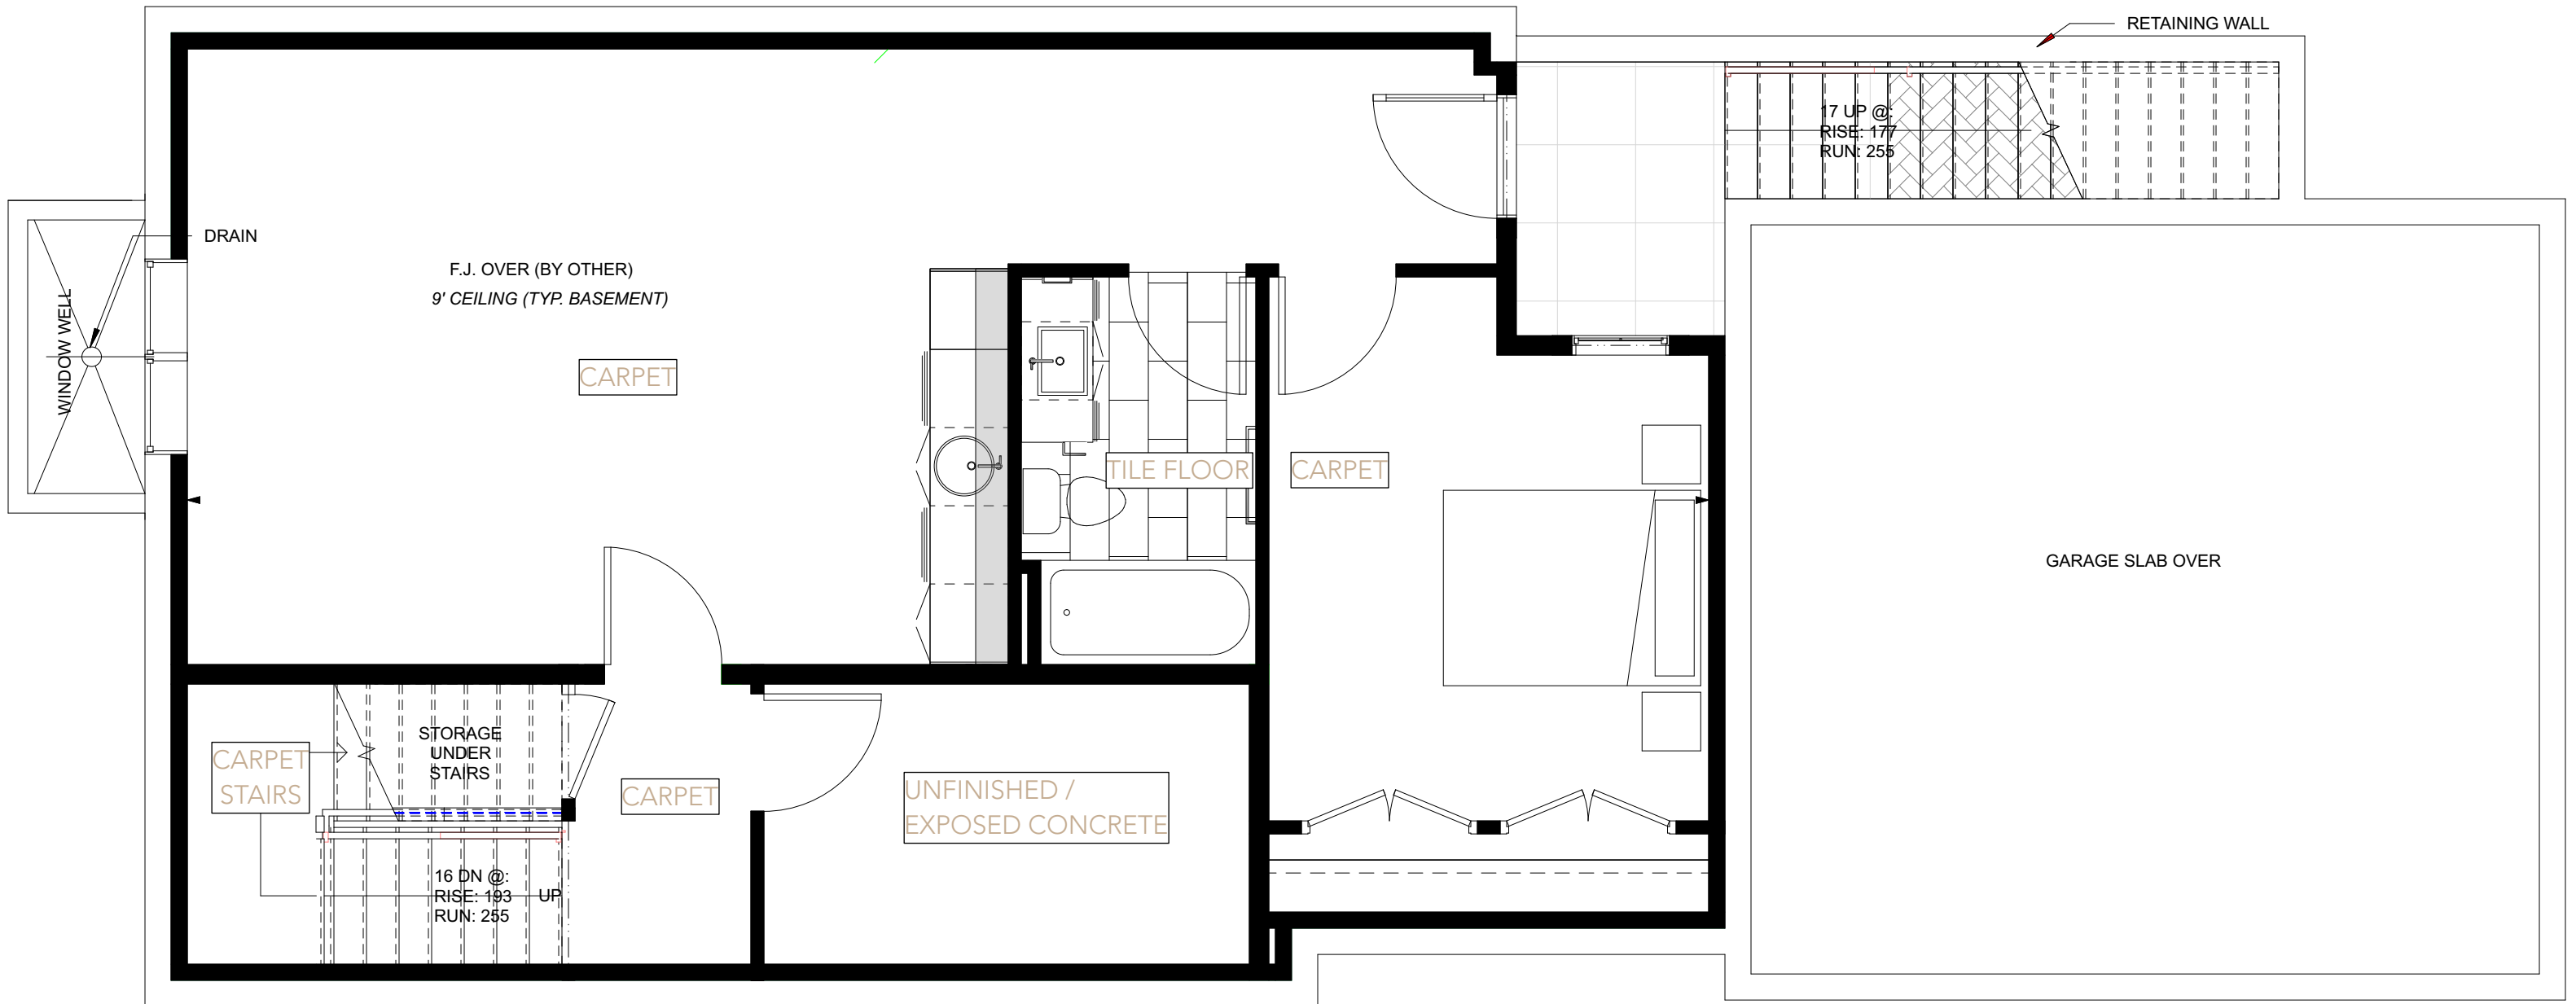

HAMPSHIRE MEWS
LOT 4 - LIGHT SCHEME
BASEMENT FINISHES PLAN
03.01.23



STAIR WALL MOULDING INSPIRATION

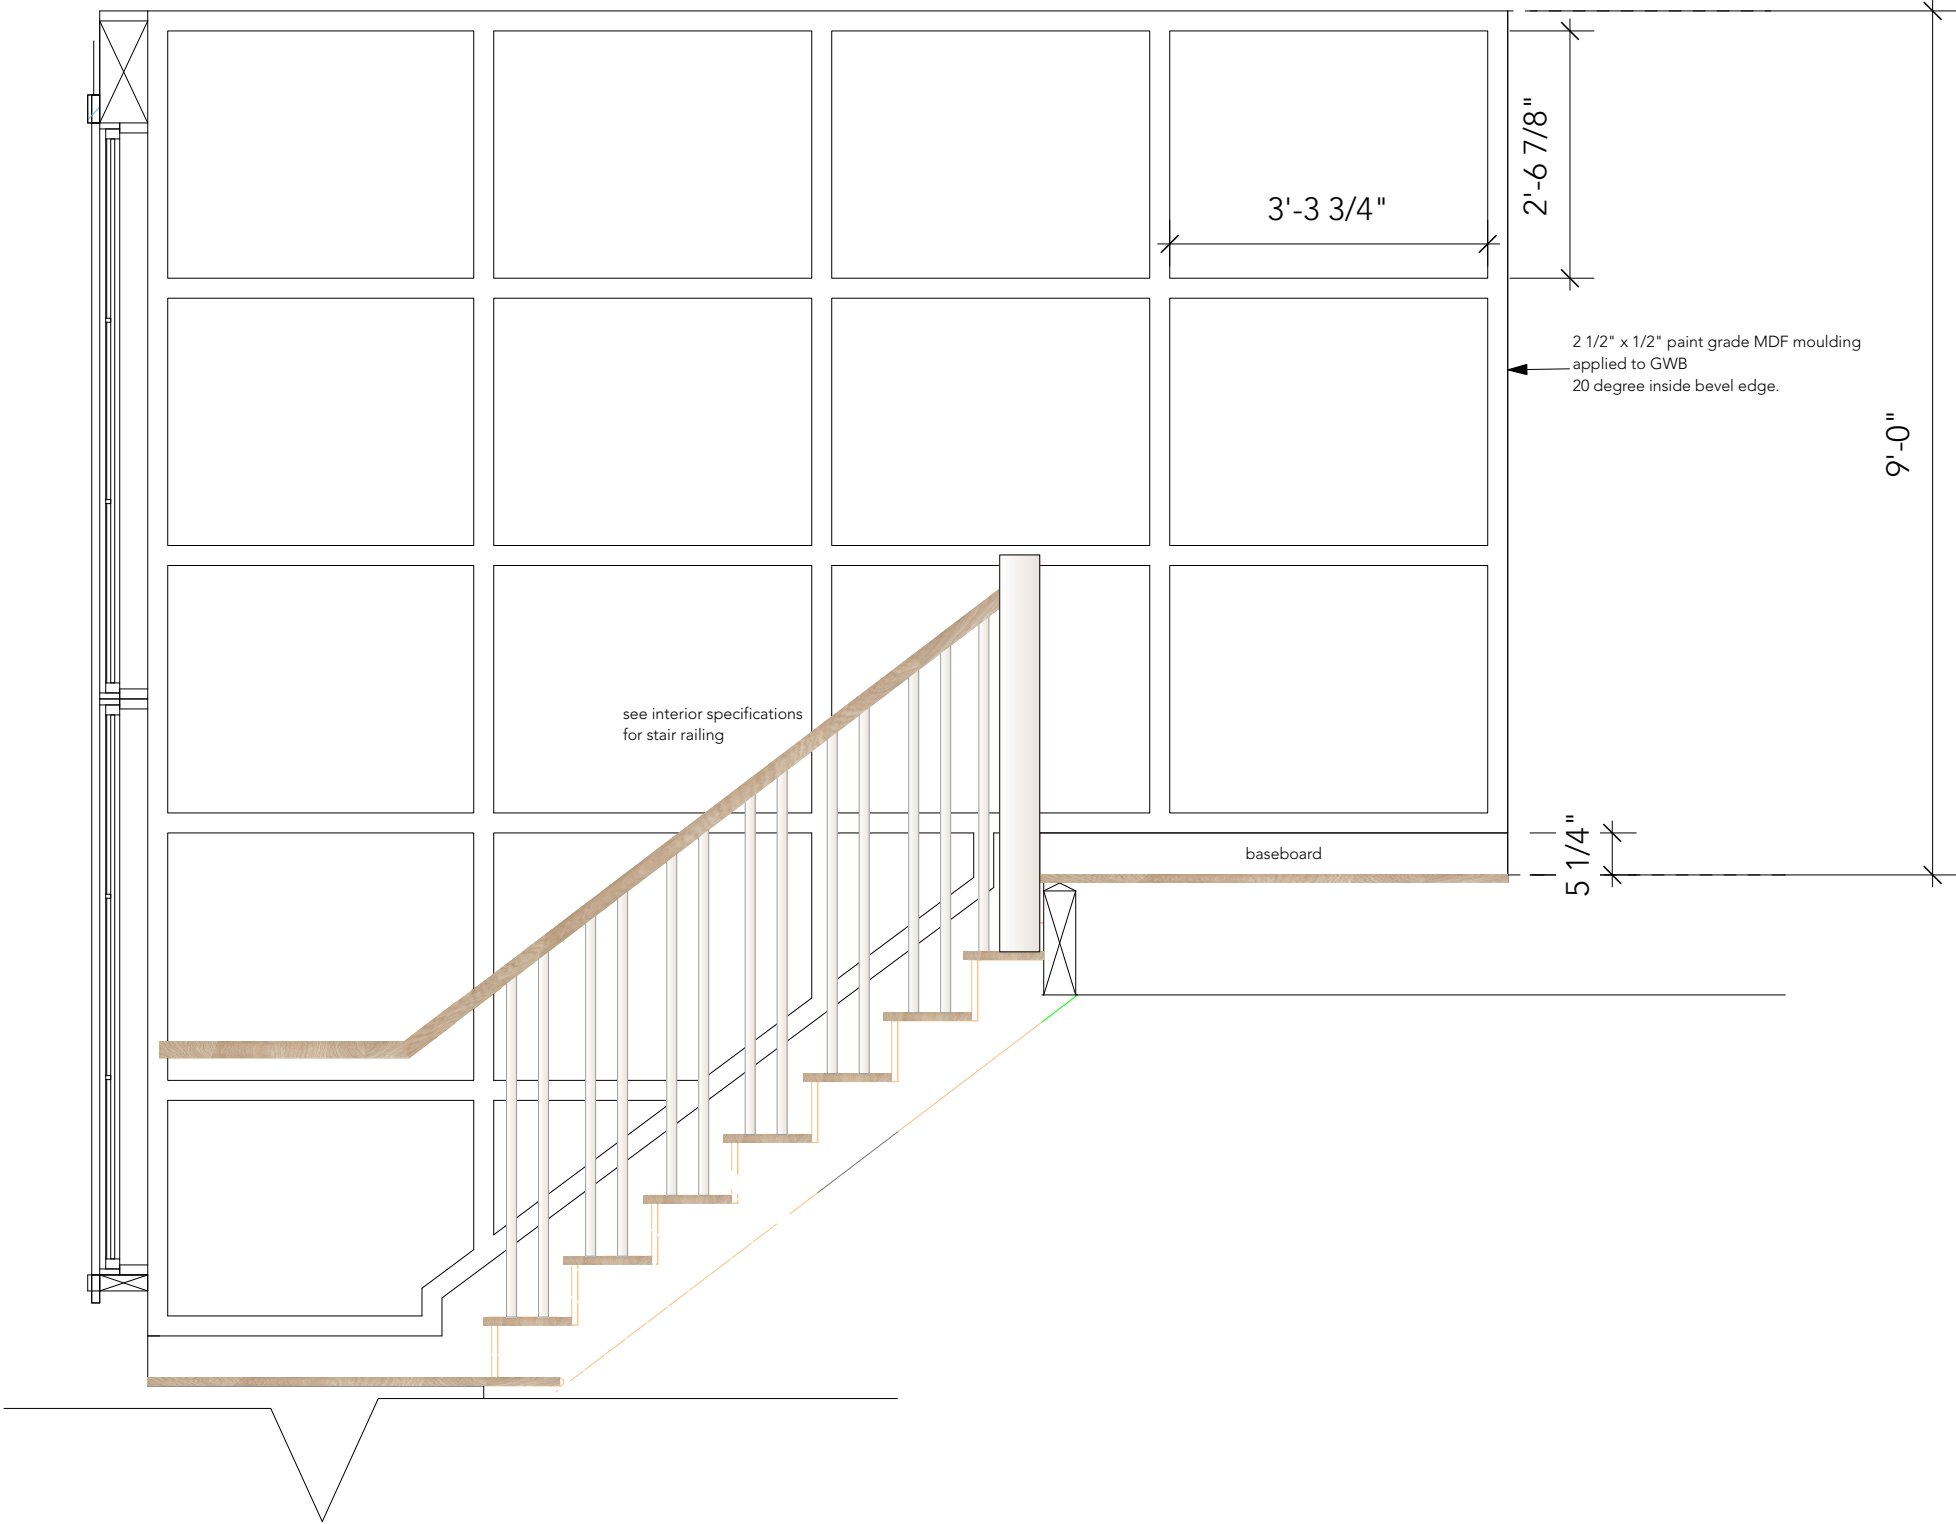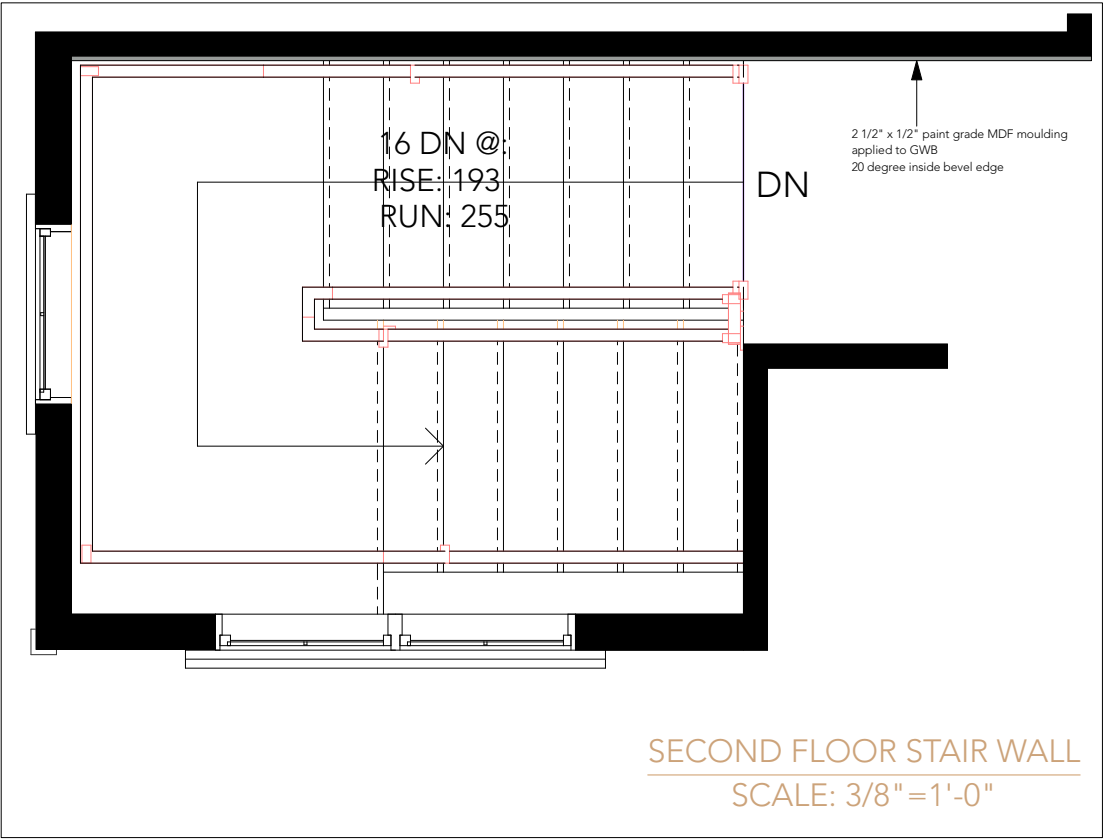

SECOND FLOOR STAIR WALL ELEVATION
SCALE: 1/2"=1'-0"

HAMPSHIRE MEWS
LOT 4 - LIGHT SCHEME
SECOND FLOOR
STAIR WALL MOULDING
03.01.23